



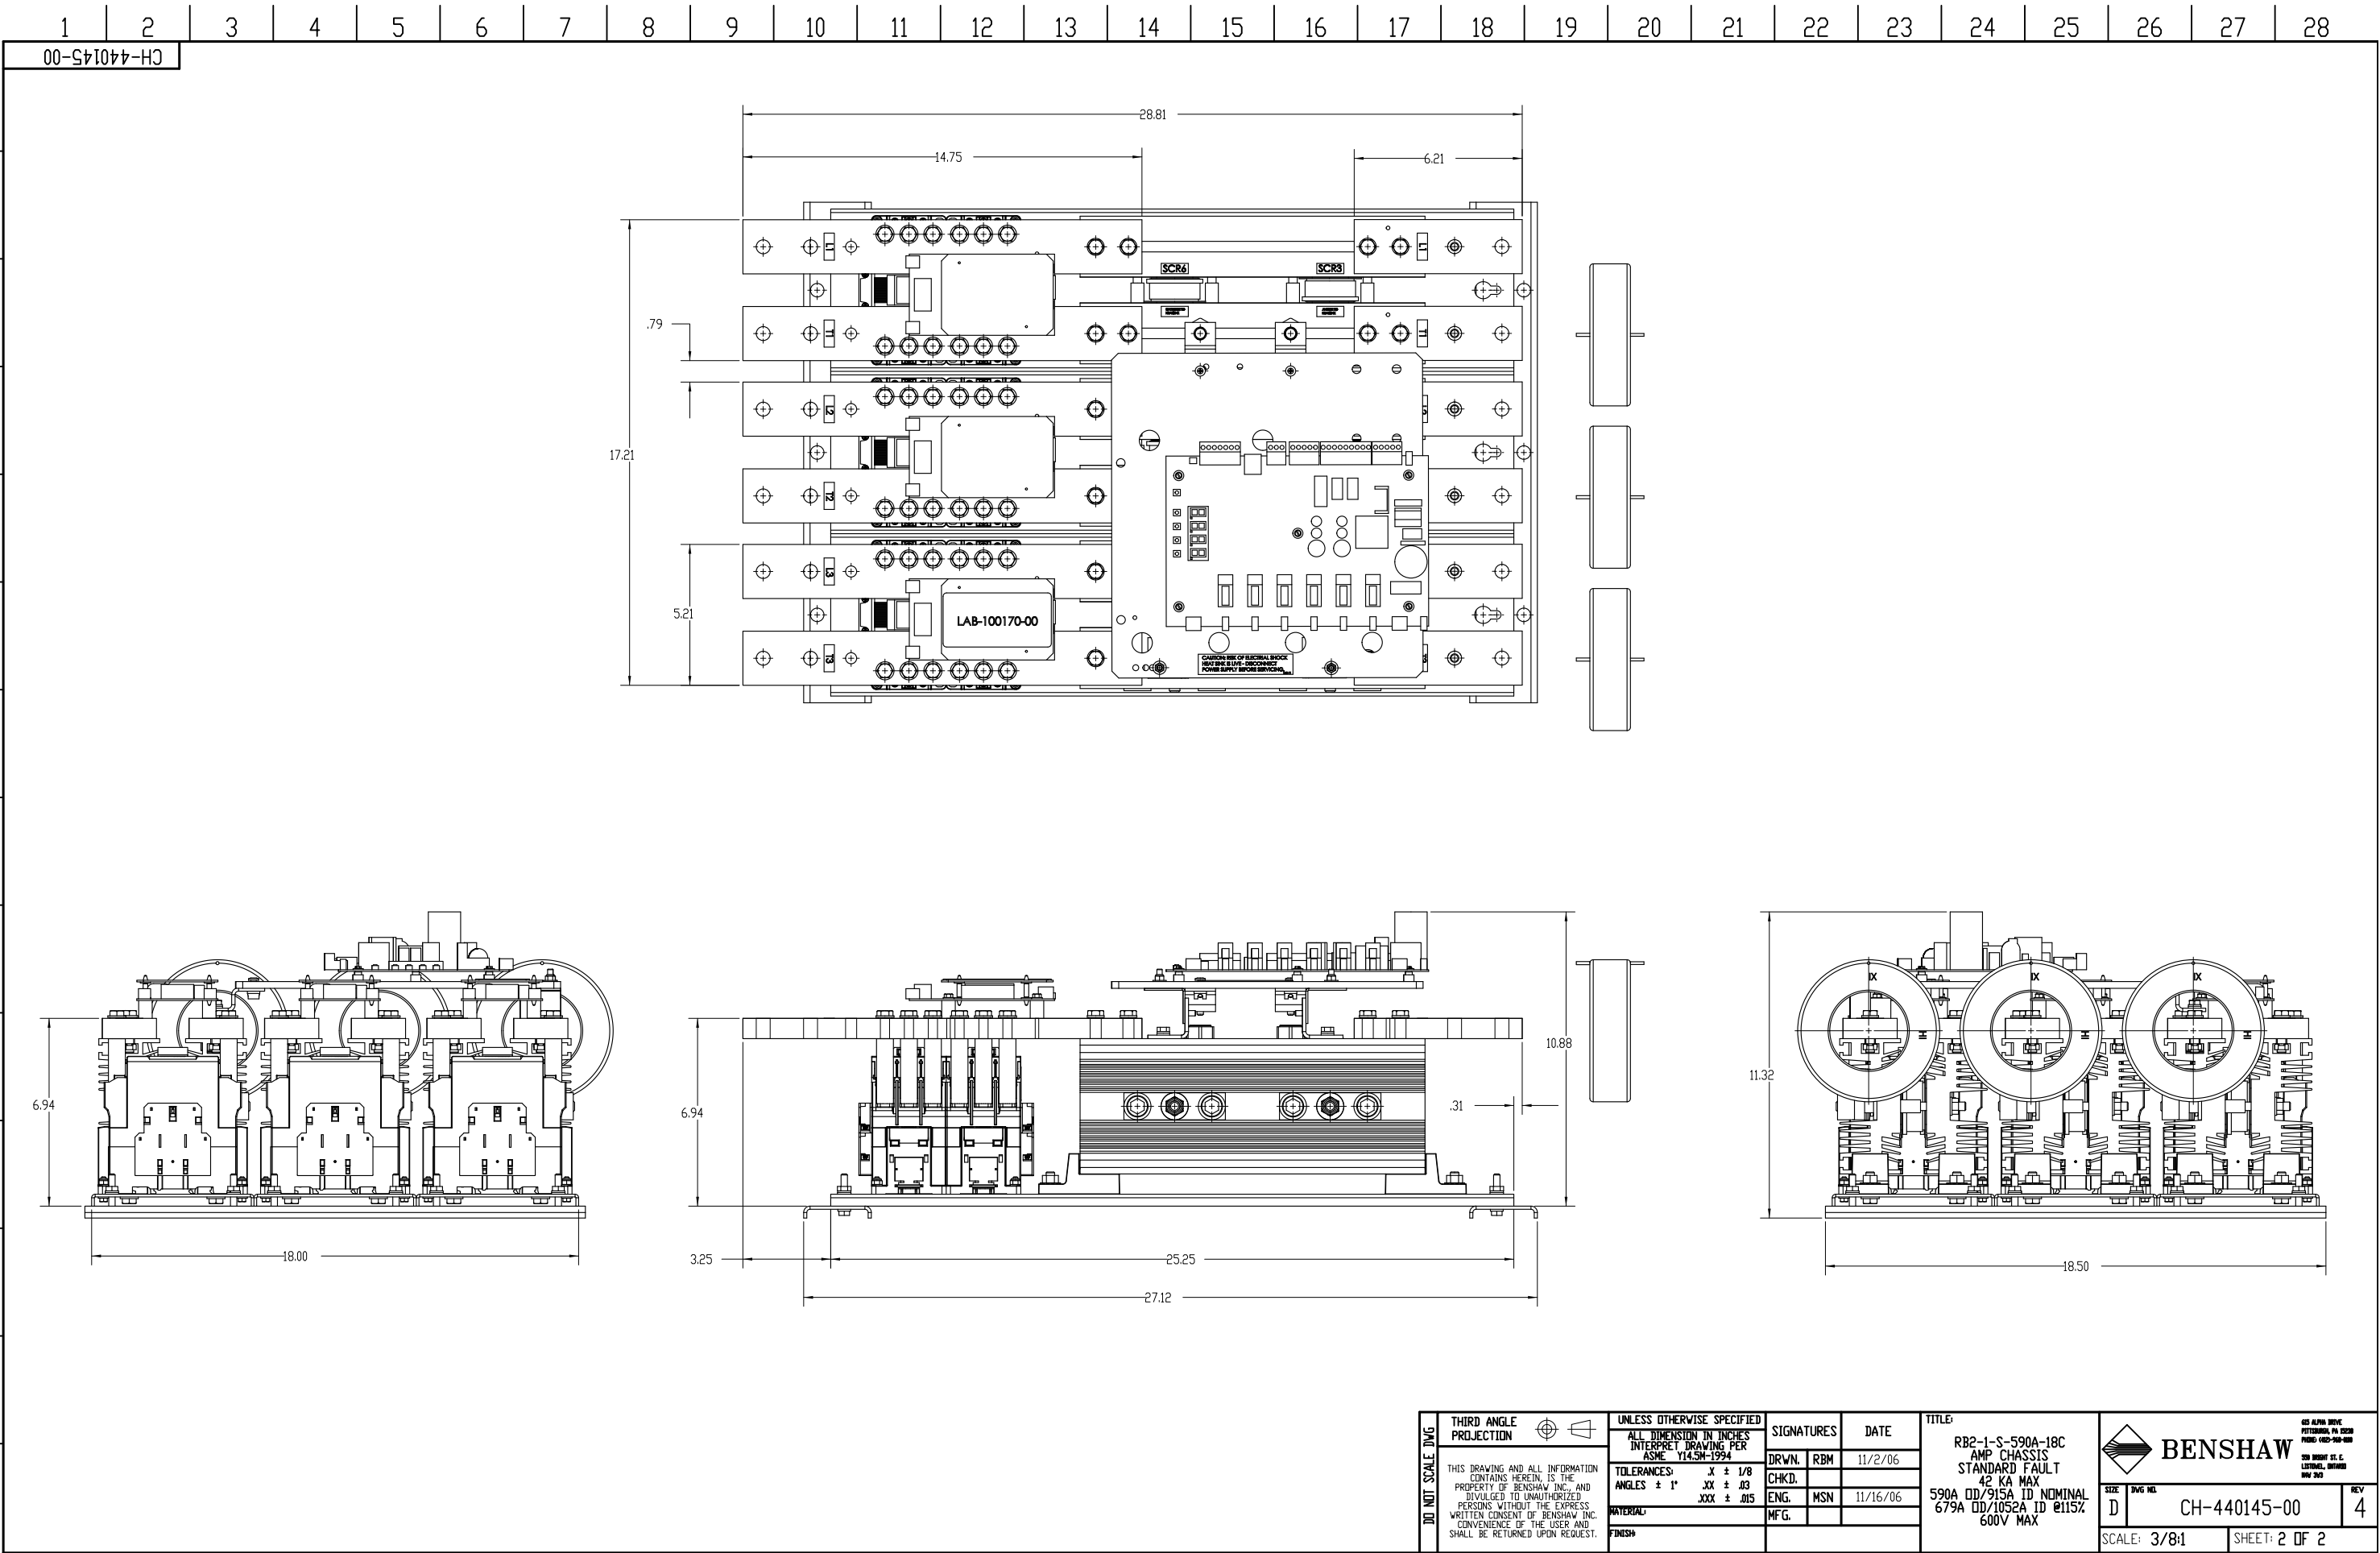




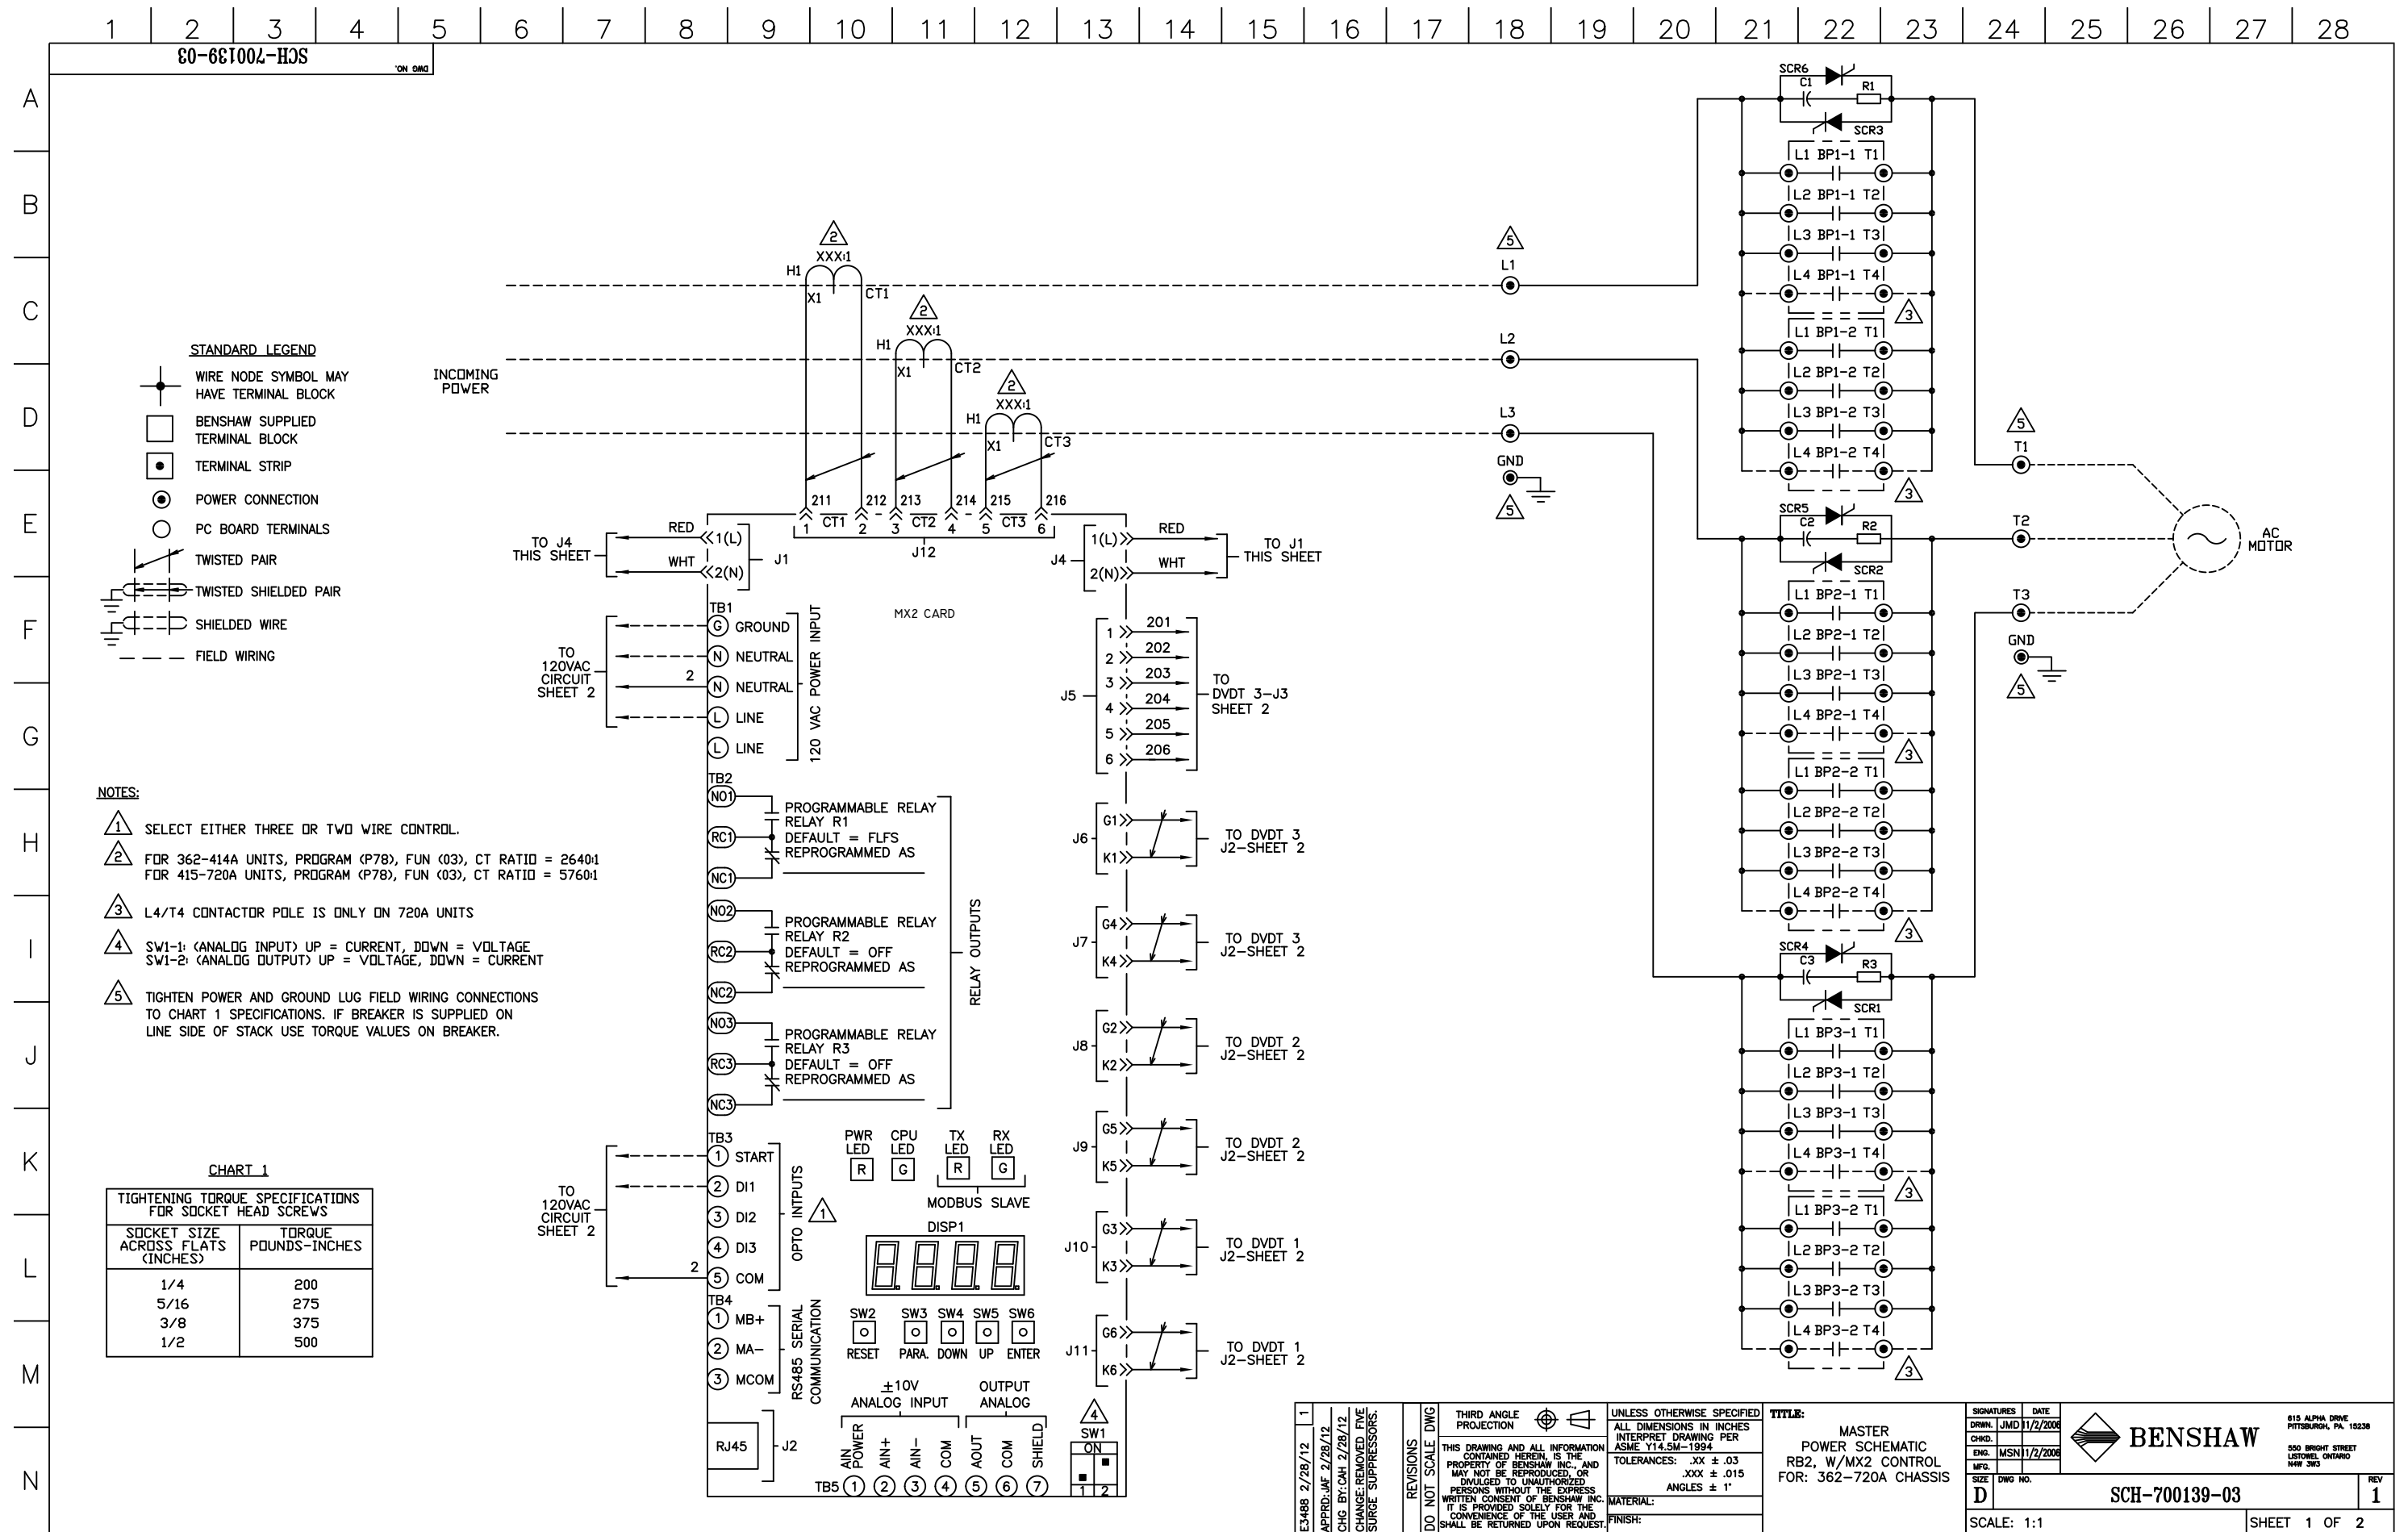


1 2 3 4 5 6 7 8 9 10 11 12 13 14 15 16 17 18 19 20 21 22 23 24 25 26 27 28

80-661004-HJS

ON DIM

TO
CUSTOMER
SUPPLIED
120VAC
CIRCUIT

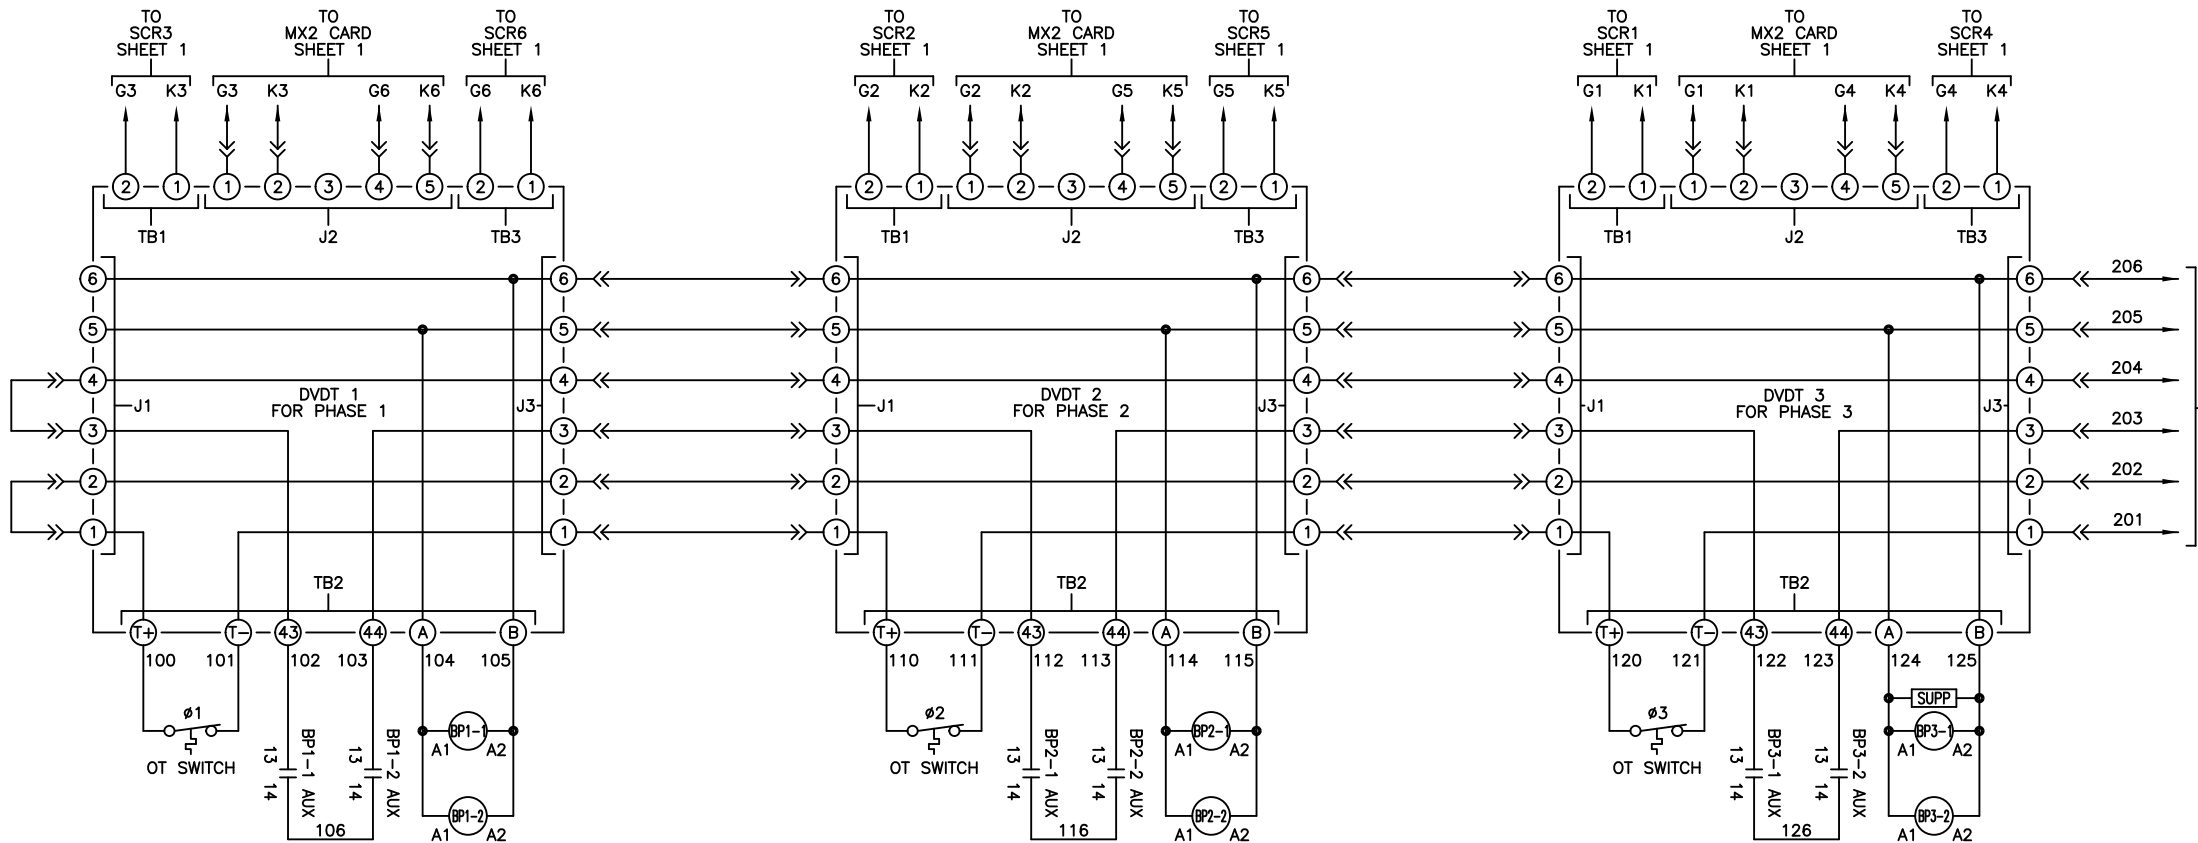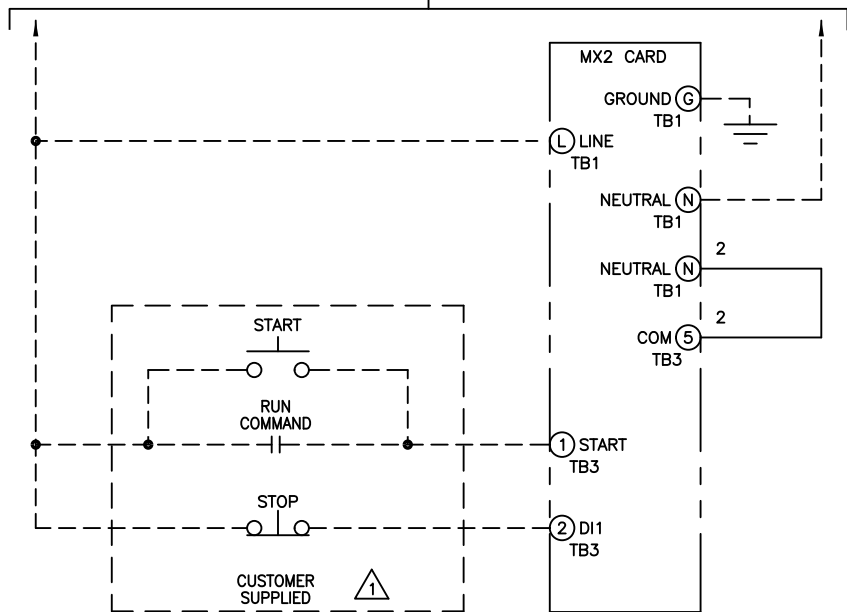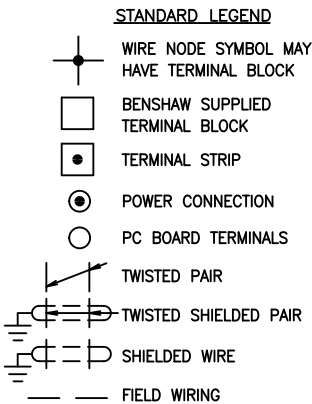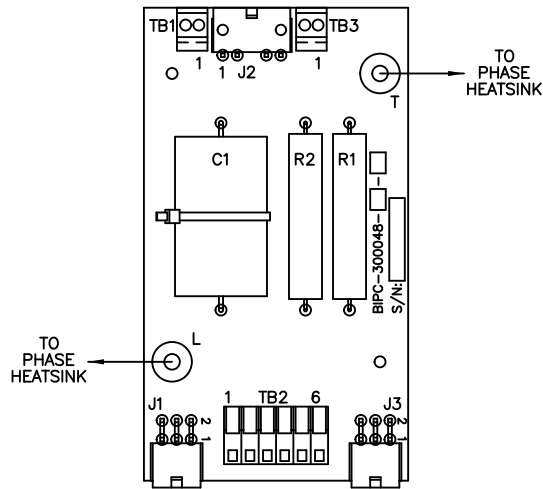

TO
MX2 CARD-J5
SHEET 1

REVISIONS DO NOT SCALE DWG	THIRD ANGLE PROJECTION	UNLESS OTHERWISE SPECIFIED ALL DIMENSIONS IN INCHES INTERPRET DRAWING PER ASME Y14.5M-1994 TOLERANCES: .XX ± .03 .XXX ± .015 ANGLES ± 1° MATERIAL: FINISH:	TITLE: MASTER CONTROL SCHEMATIC RB2, W/MX2 CONTROL FOR: 362-720A CHASSIS	SIGNATURES	DATE		815 ALPHA DRIVE PITTSBURGH, PA. 15238 550 BRIGHT STREET LUTHERVILLE, ONTARIO N4W 3W5
	DRWN.			JMD	11/2/2006		
	CHKD.			MSN	11/2/2006		
	ENG.			MSN	11/2/2006		
SIZE	D	DWG NO.	SCH-700139-03	REV	1		
SCALE: 1:1				SHEET 2 OF 2			