





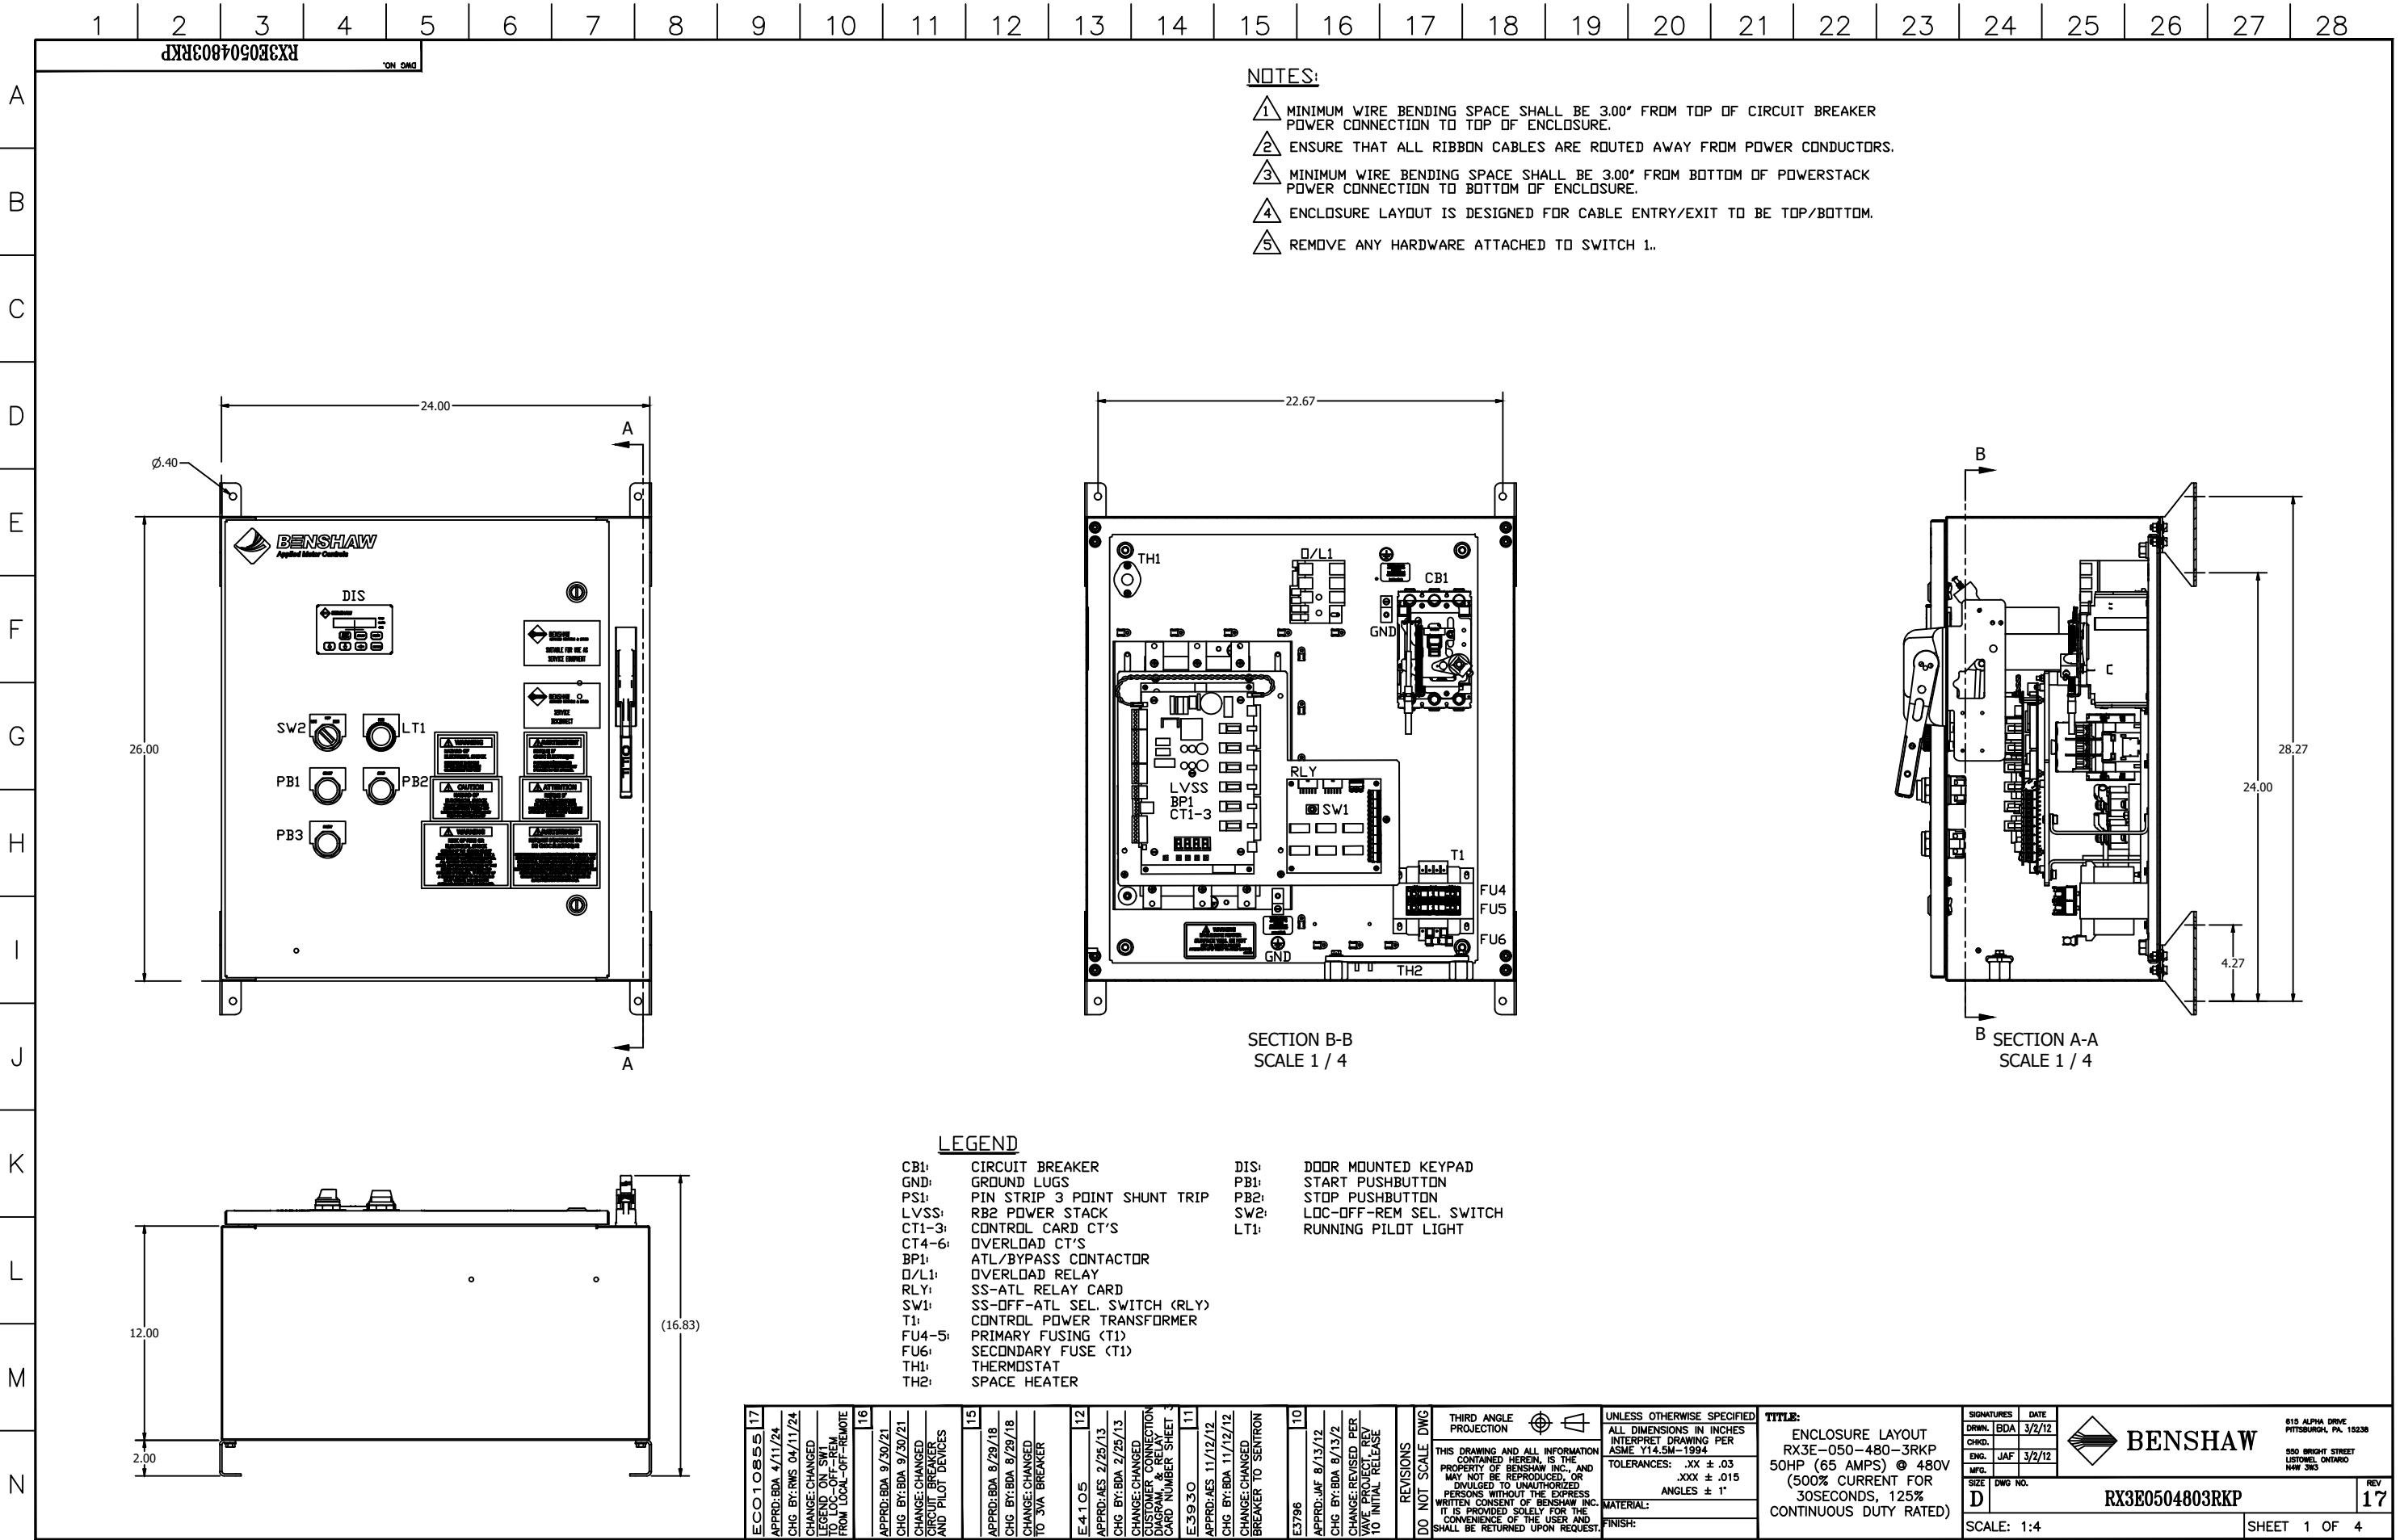

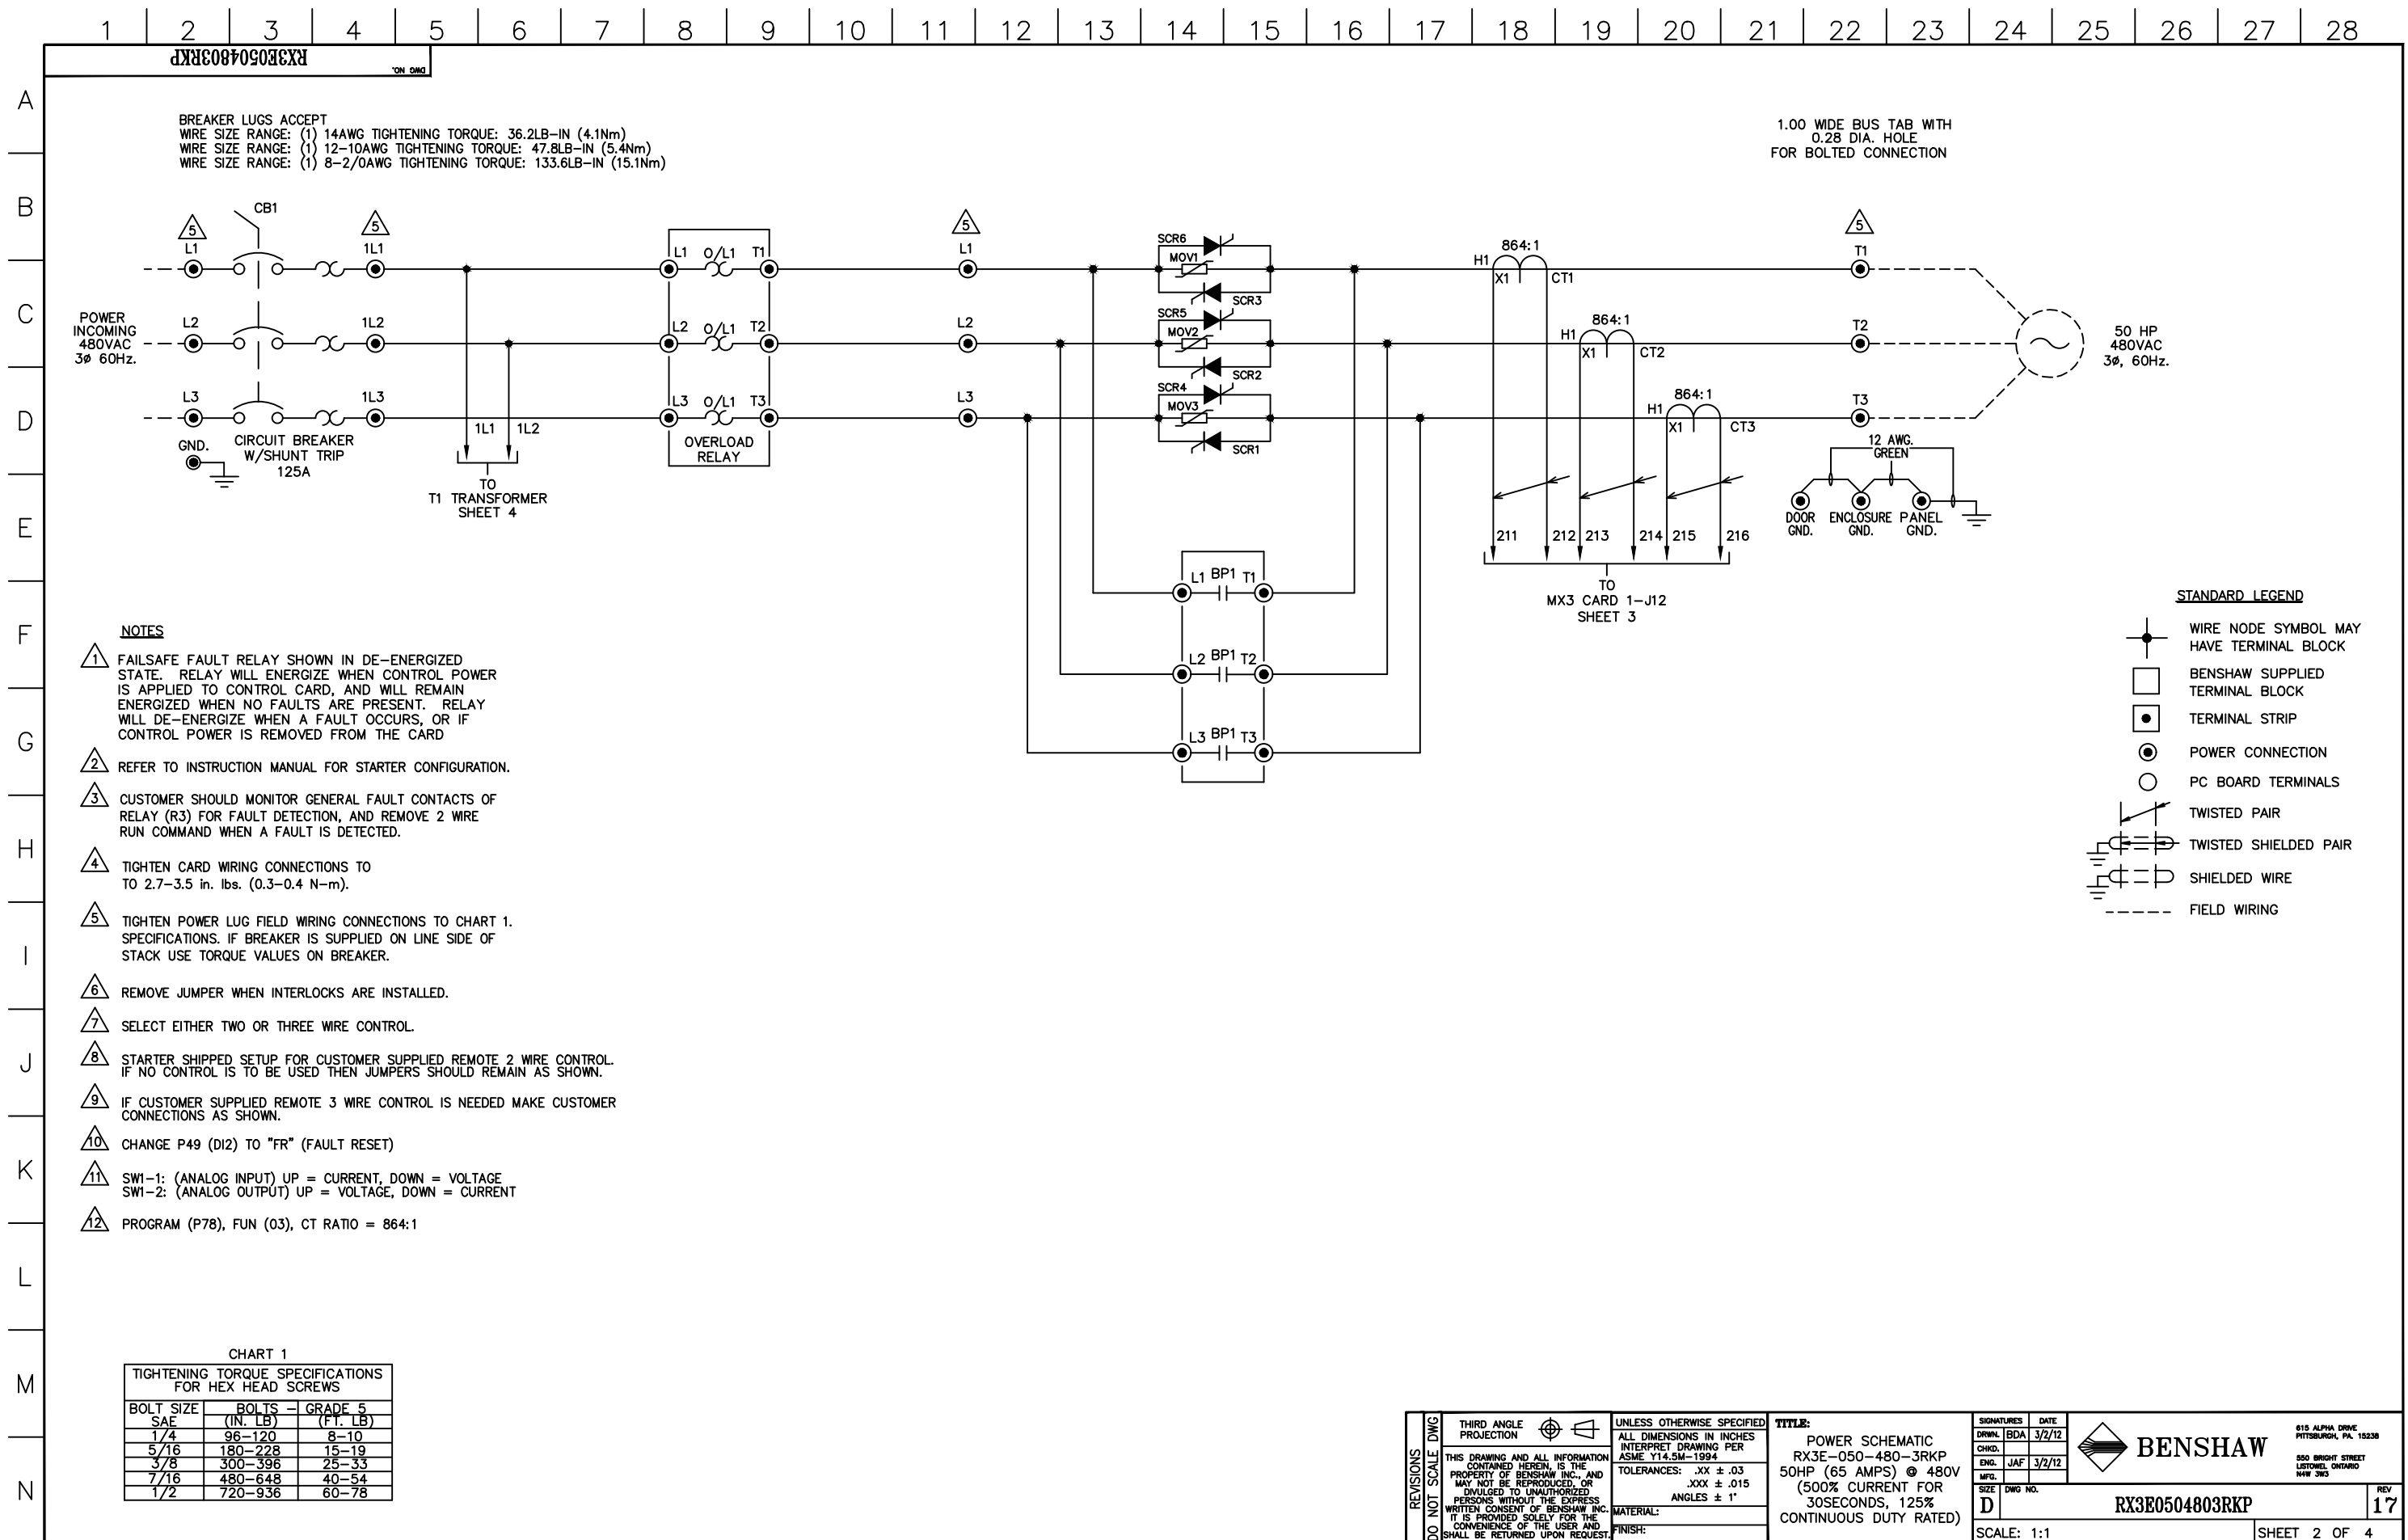

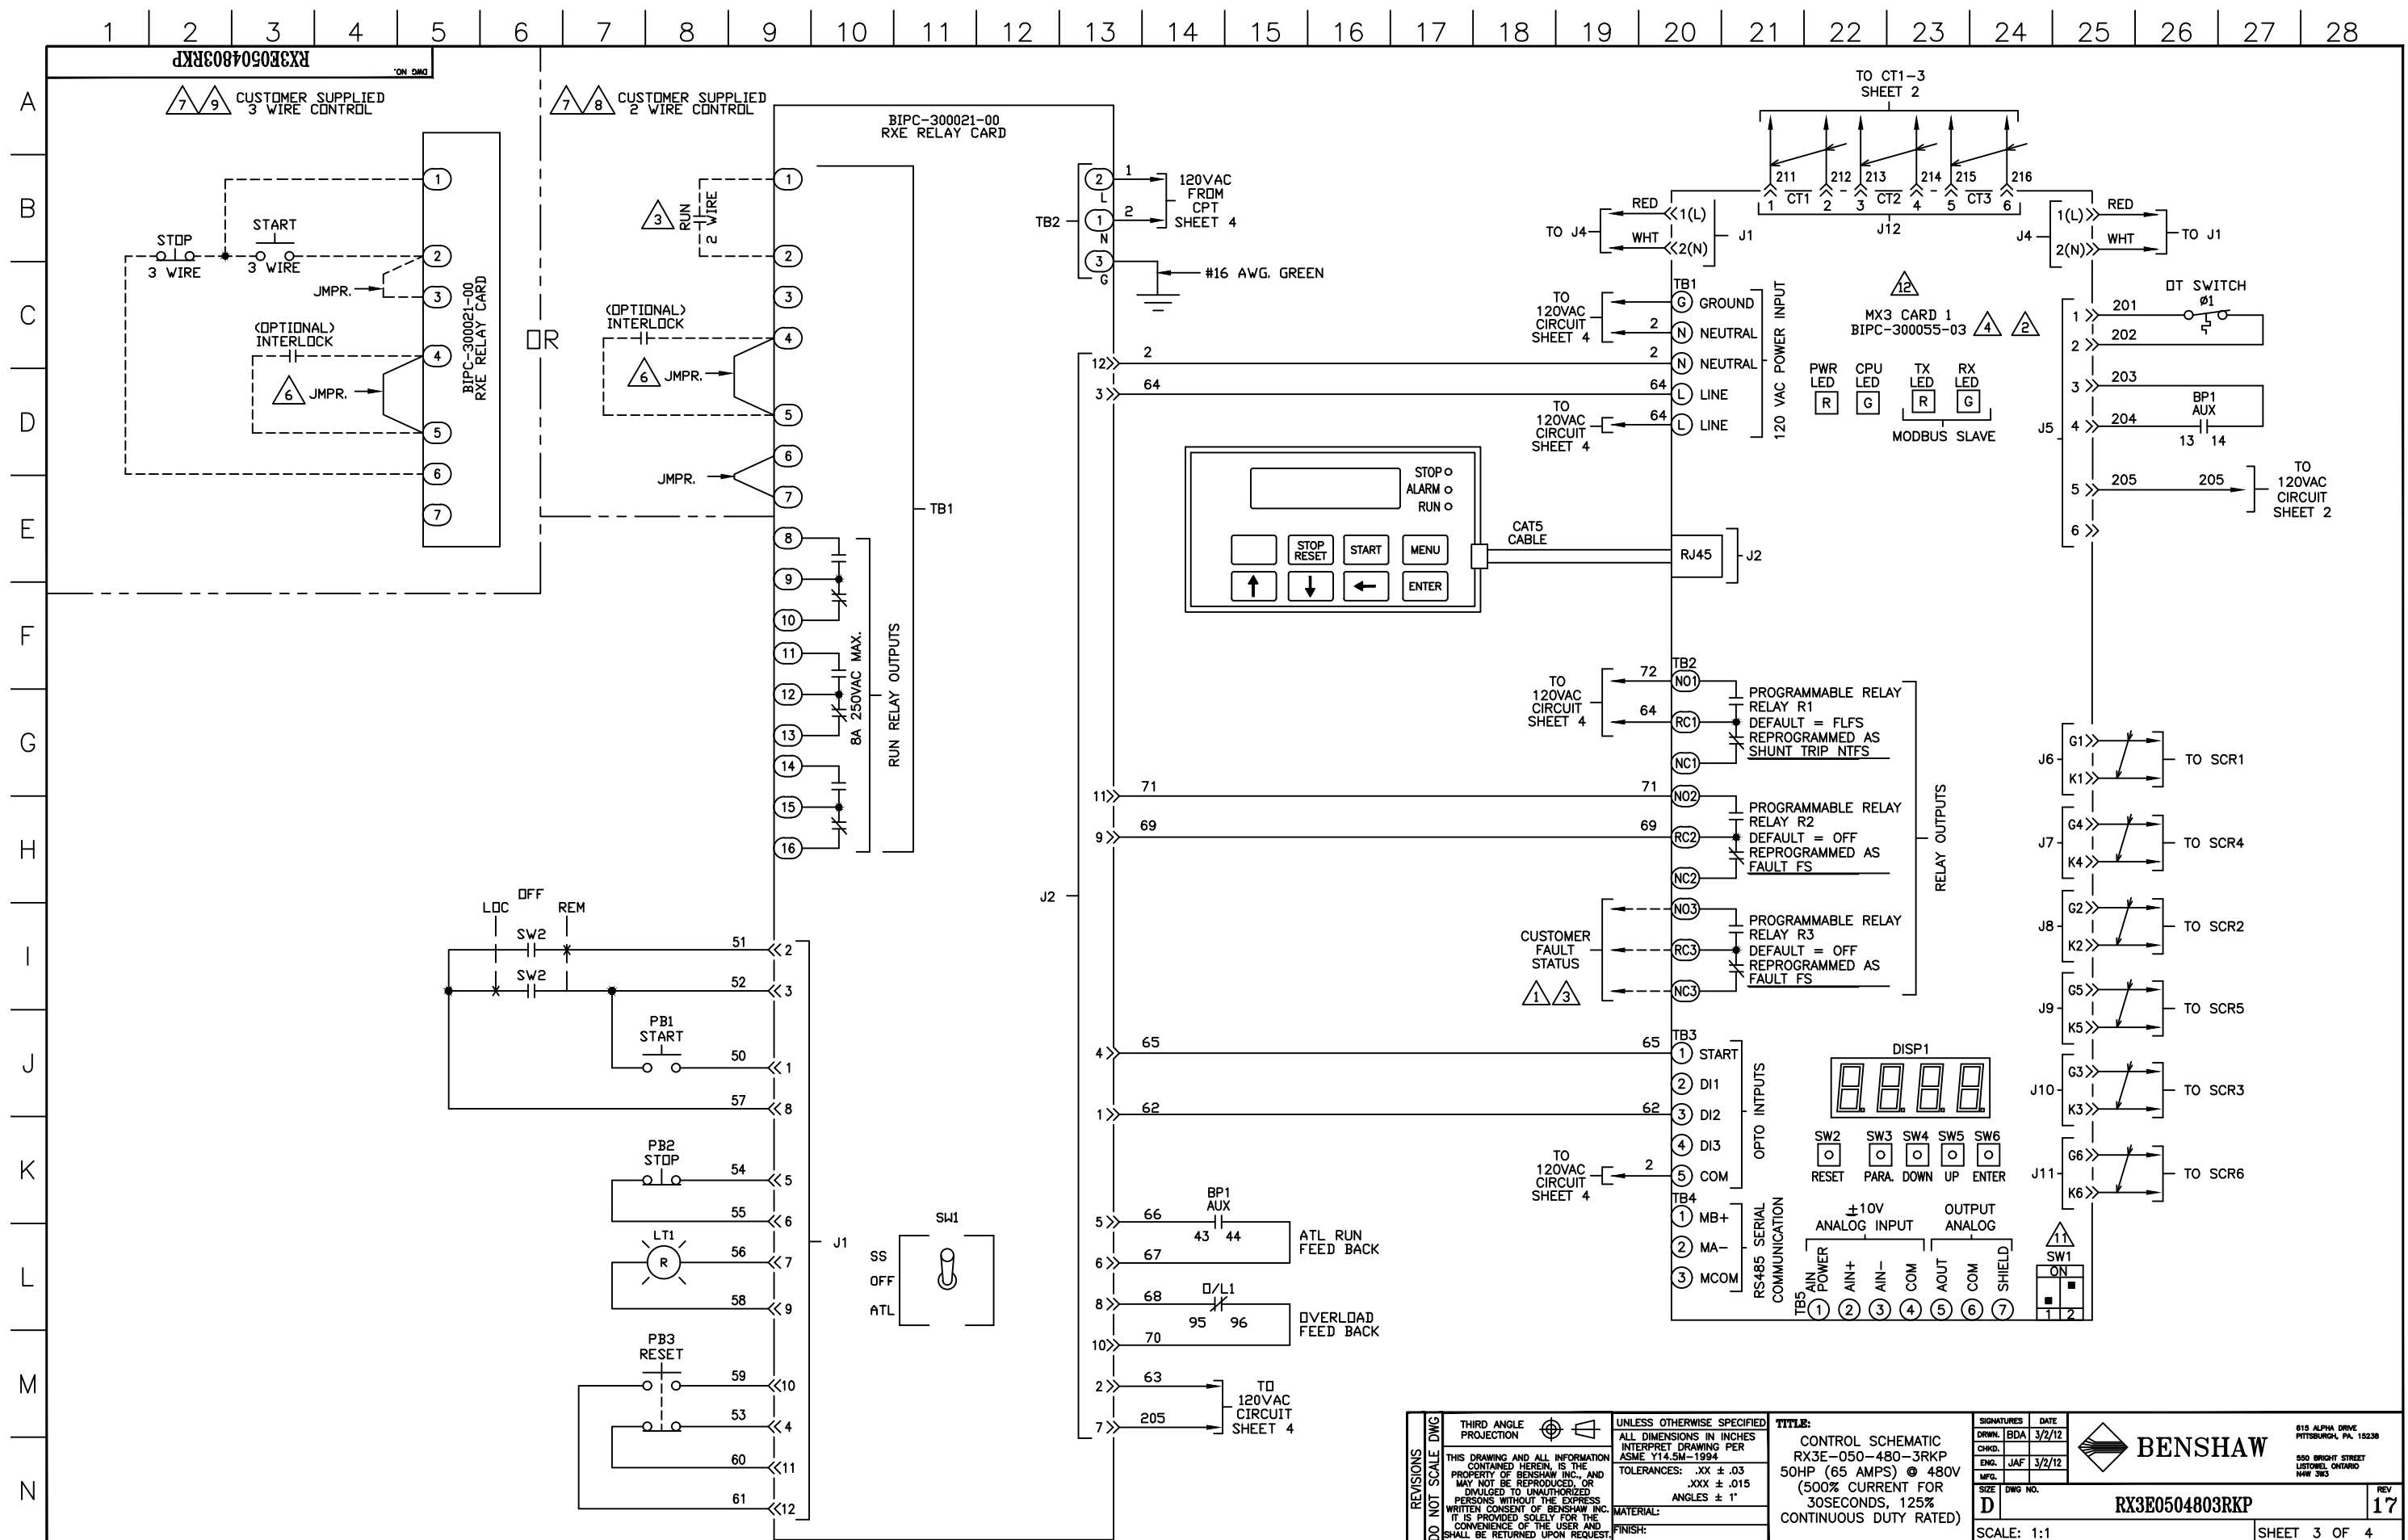

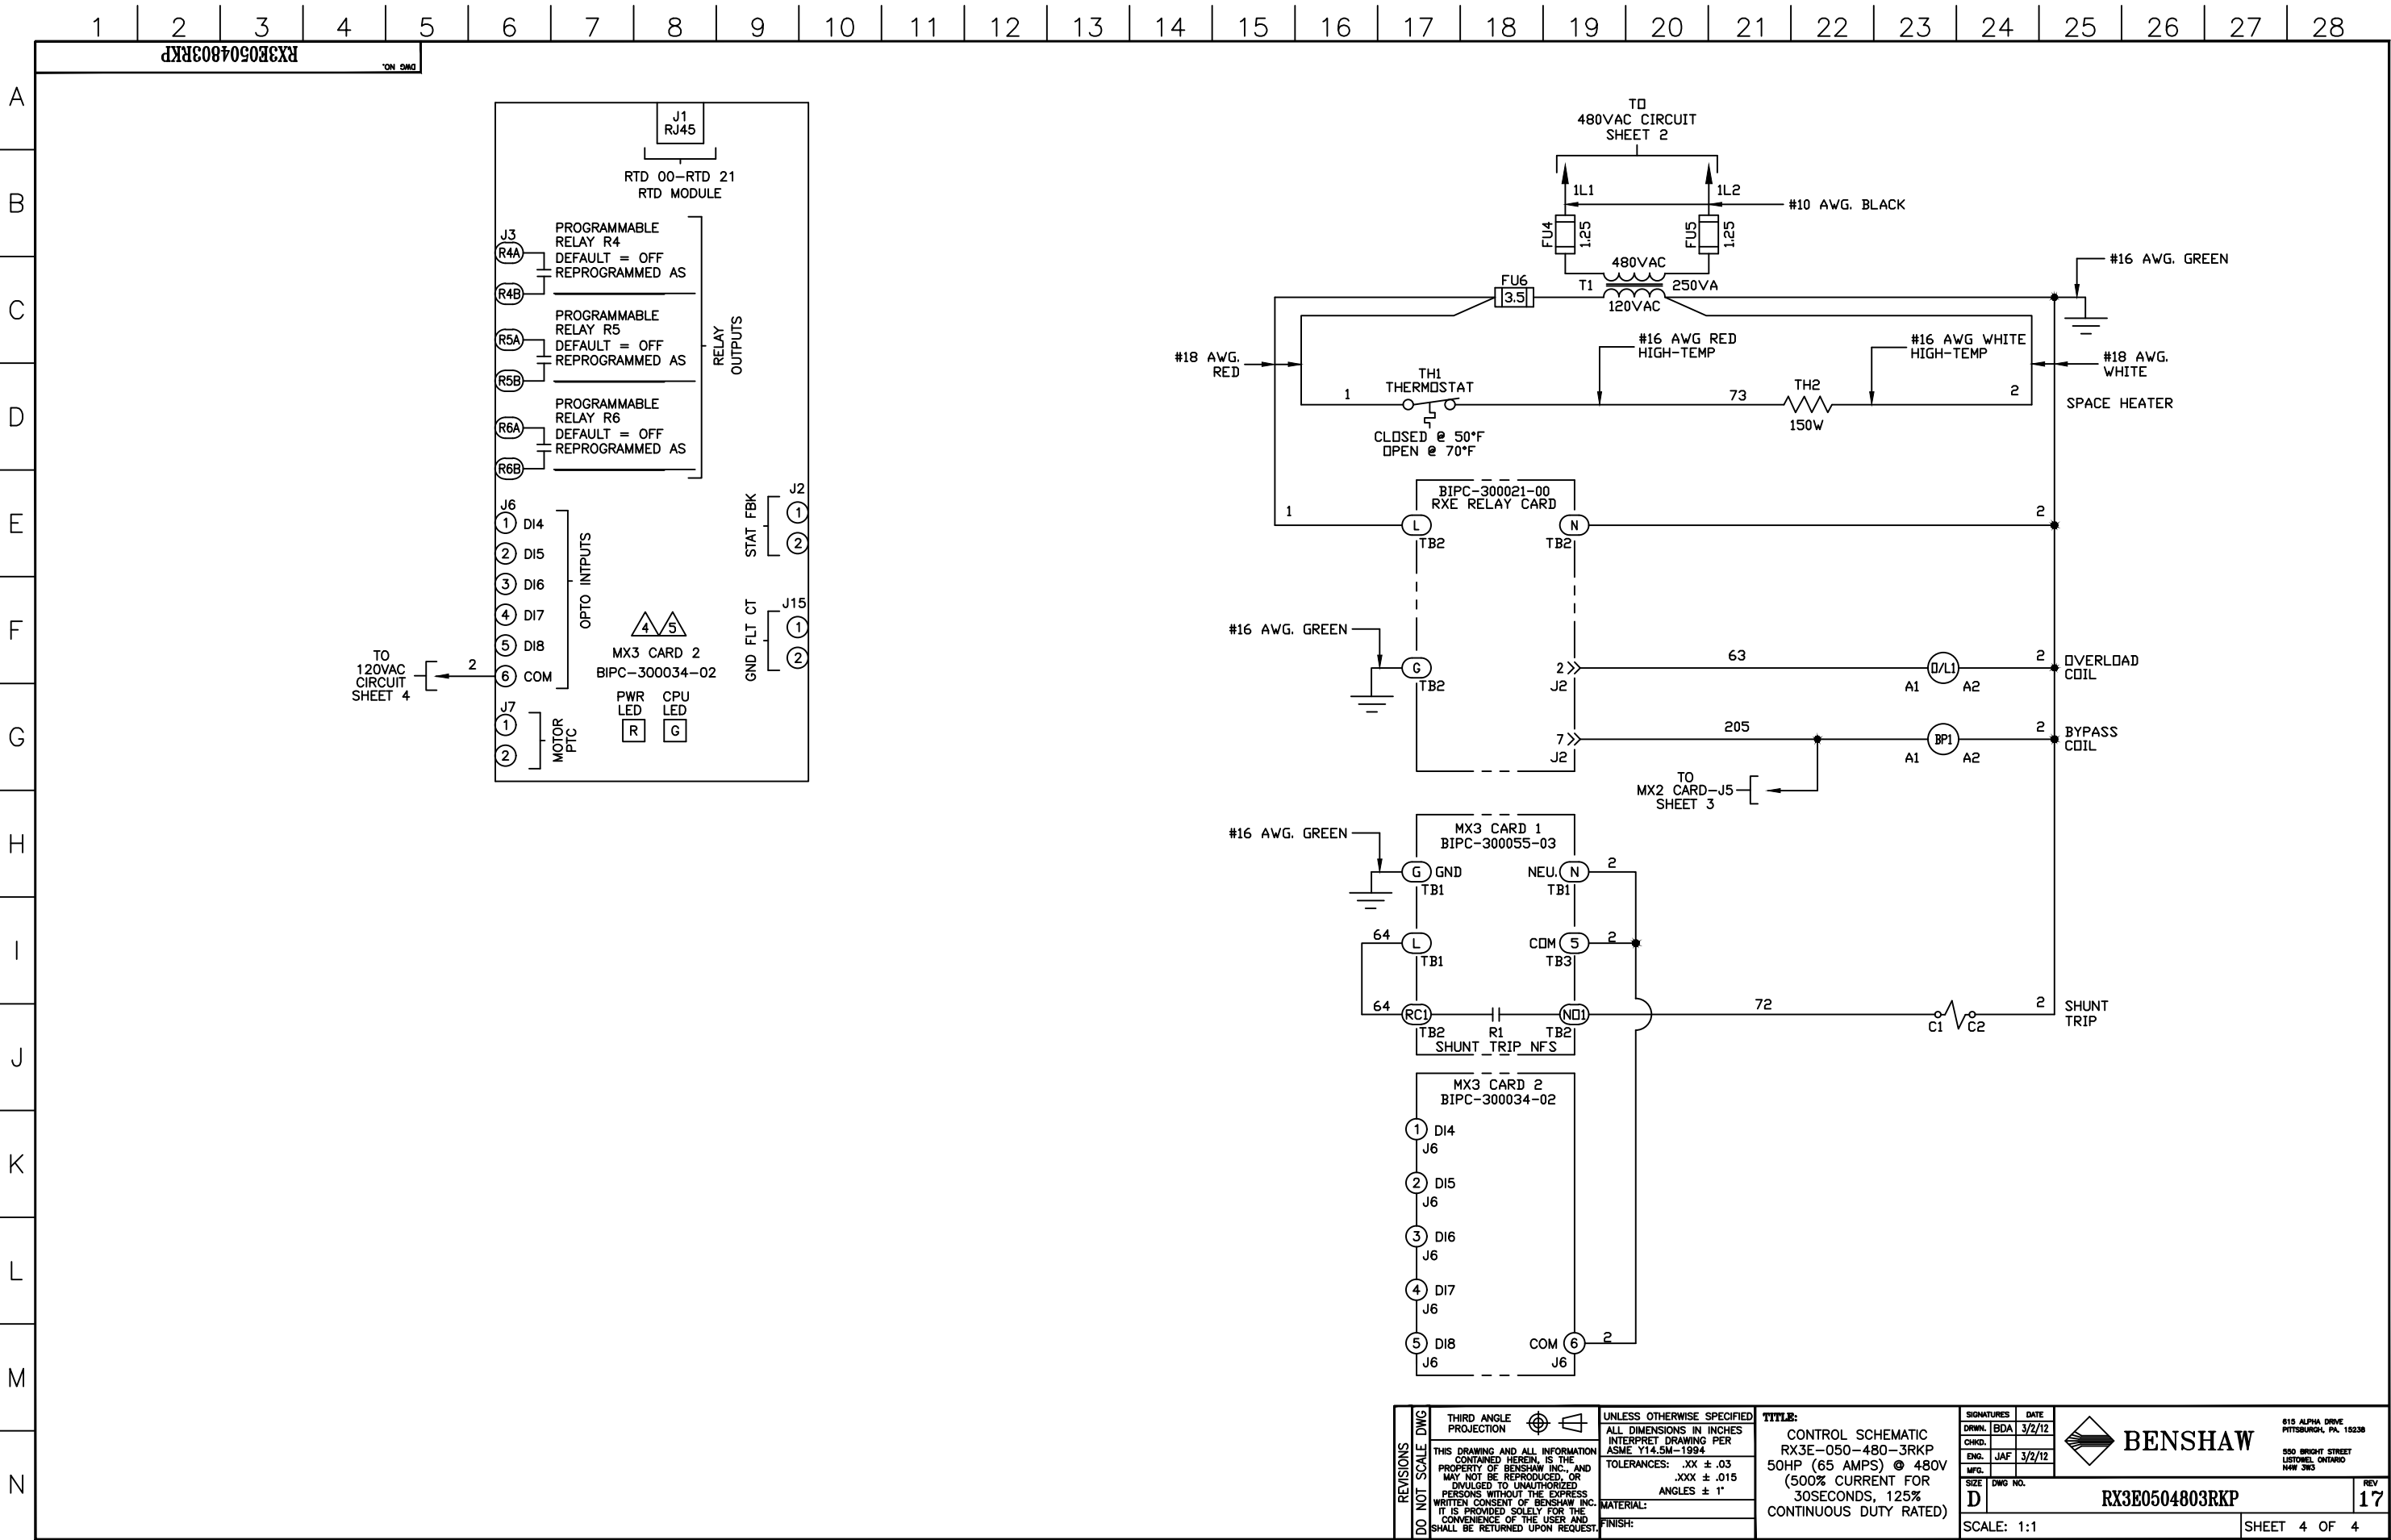

REVISIONS DO NOT SCALE DWG	THIRD ANGLE PROJECTION		UNLESS OTHERWISE SPECIFIED		TITLE: CONTROL SCHEMATIC RX3E-050-480-3RKP 50HP (65 AMPS) @ 480V (500% CURRENT FOR 30SECONDS, 125% CONTINUOUS DUTY RATED)	SIGNATURES		DATE		 BENSHAW 815 ALPHA DRIVE PITTSBURGH, PA. 15238 550 BRIGHT STREET LISTOWEL, ONTARIO N4W 5H5	REV 17
	THIS DRAWING AND ALL INFORMATION CONTAINED HEREIN, IS THE PROPERTY OF BENSHAW INC., AND MAY NOT BE REPRODUCED, OR COPIED TO UNAUTHORIZED PERSONS WITHOUT THE EXPRESS WRITTEN CONSENT OF BENSHAW INC. IT IS PROVIDED SOLELY FOR THE CONVENIENCE OF THE USER AND SHALL BE RETURNED UPON REQUEST.		ALL DIMENSIONS IN INCHES INTERPRET DRAWING PER ASME Y14.5M-1994			DRWN. BDA 3/2/12					
			TOLERANCES: .XX ± .03 .XXX ± .015 ANGLES ± 1°			CHKD.					
			MATERIAL:			ENG. JAF 3/2/12					
	FINISH:					SIZE DWG NO.					
						D			RX3E0504803RKP		
					SCALE: 1:1	SHEET 4 OF 4					