




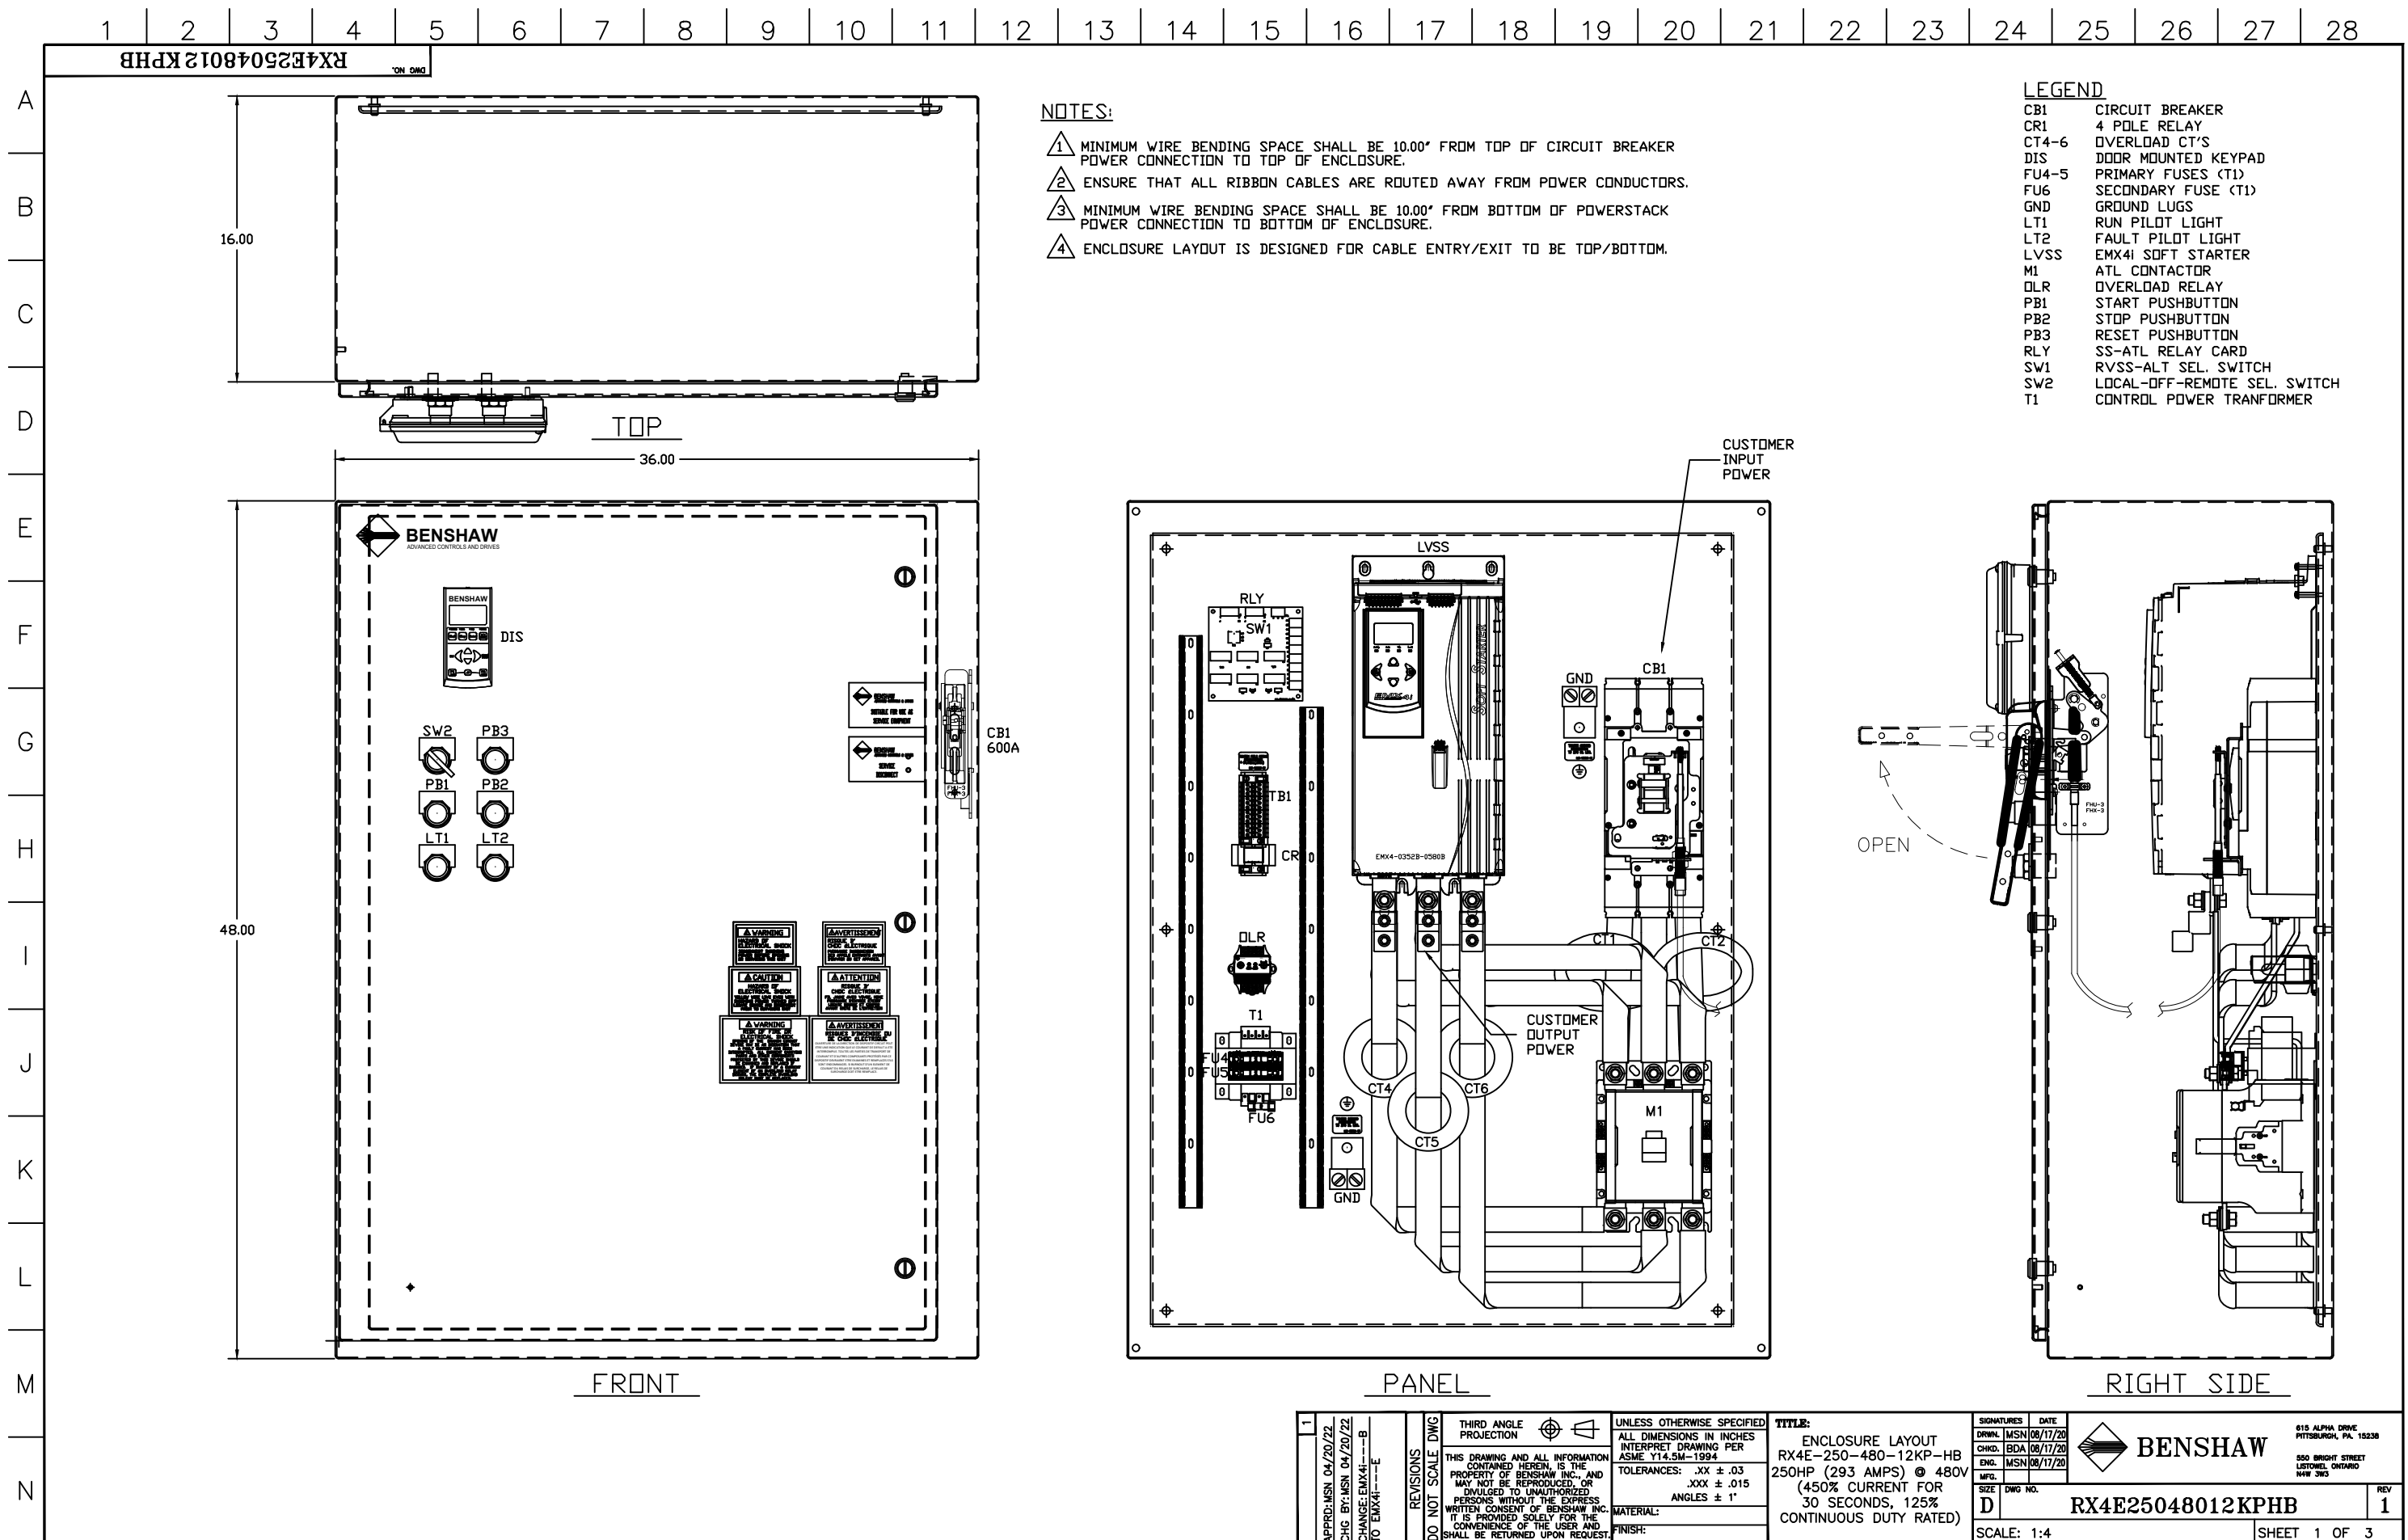

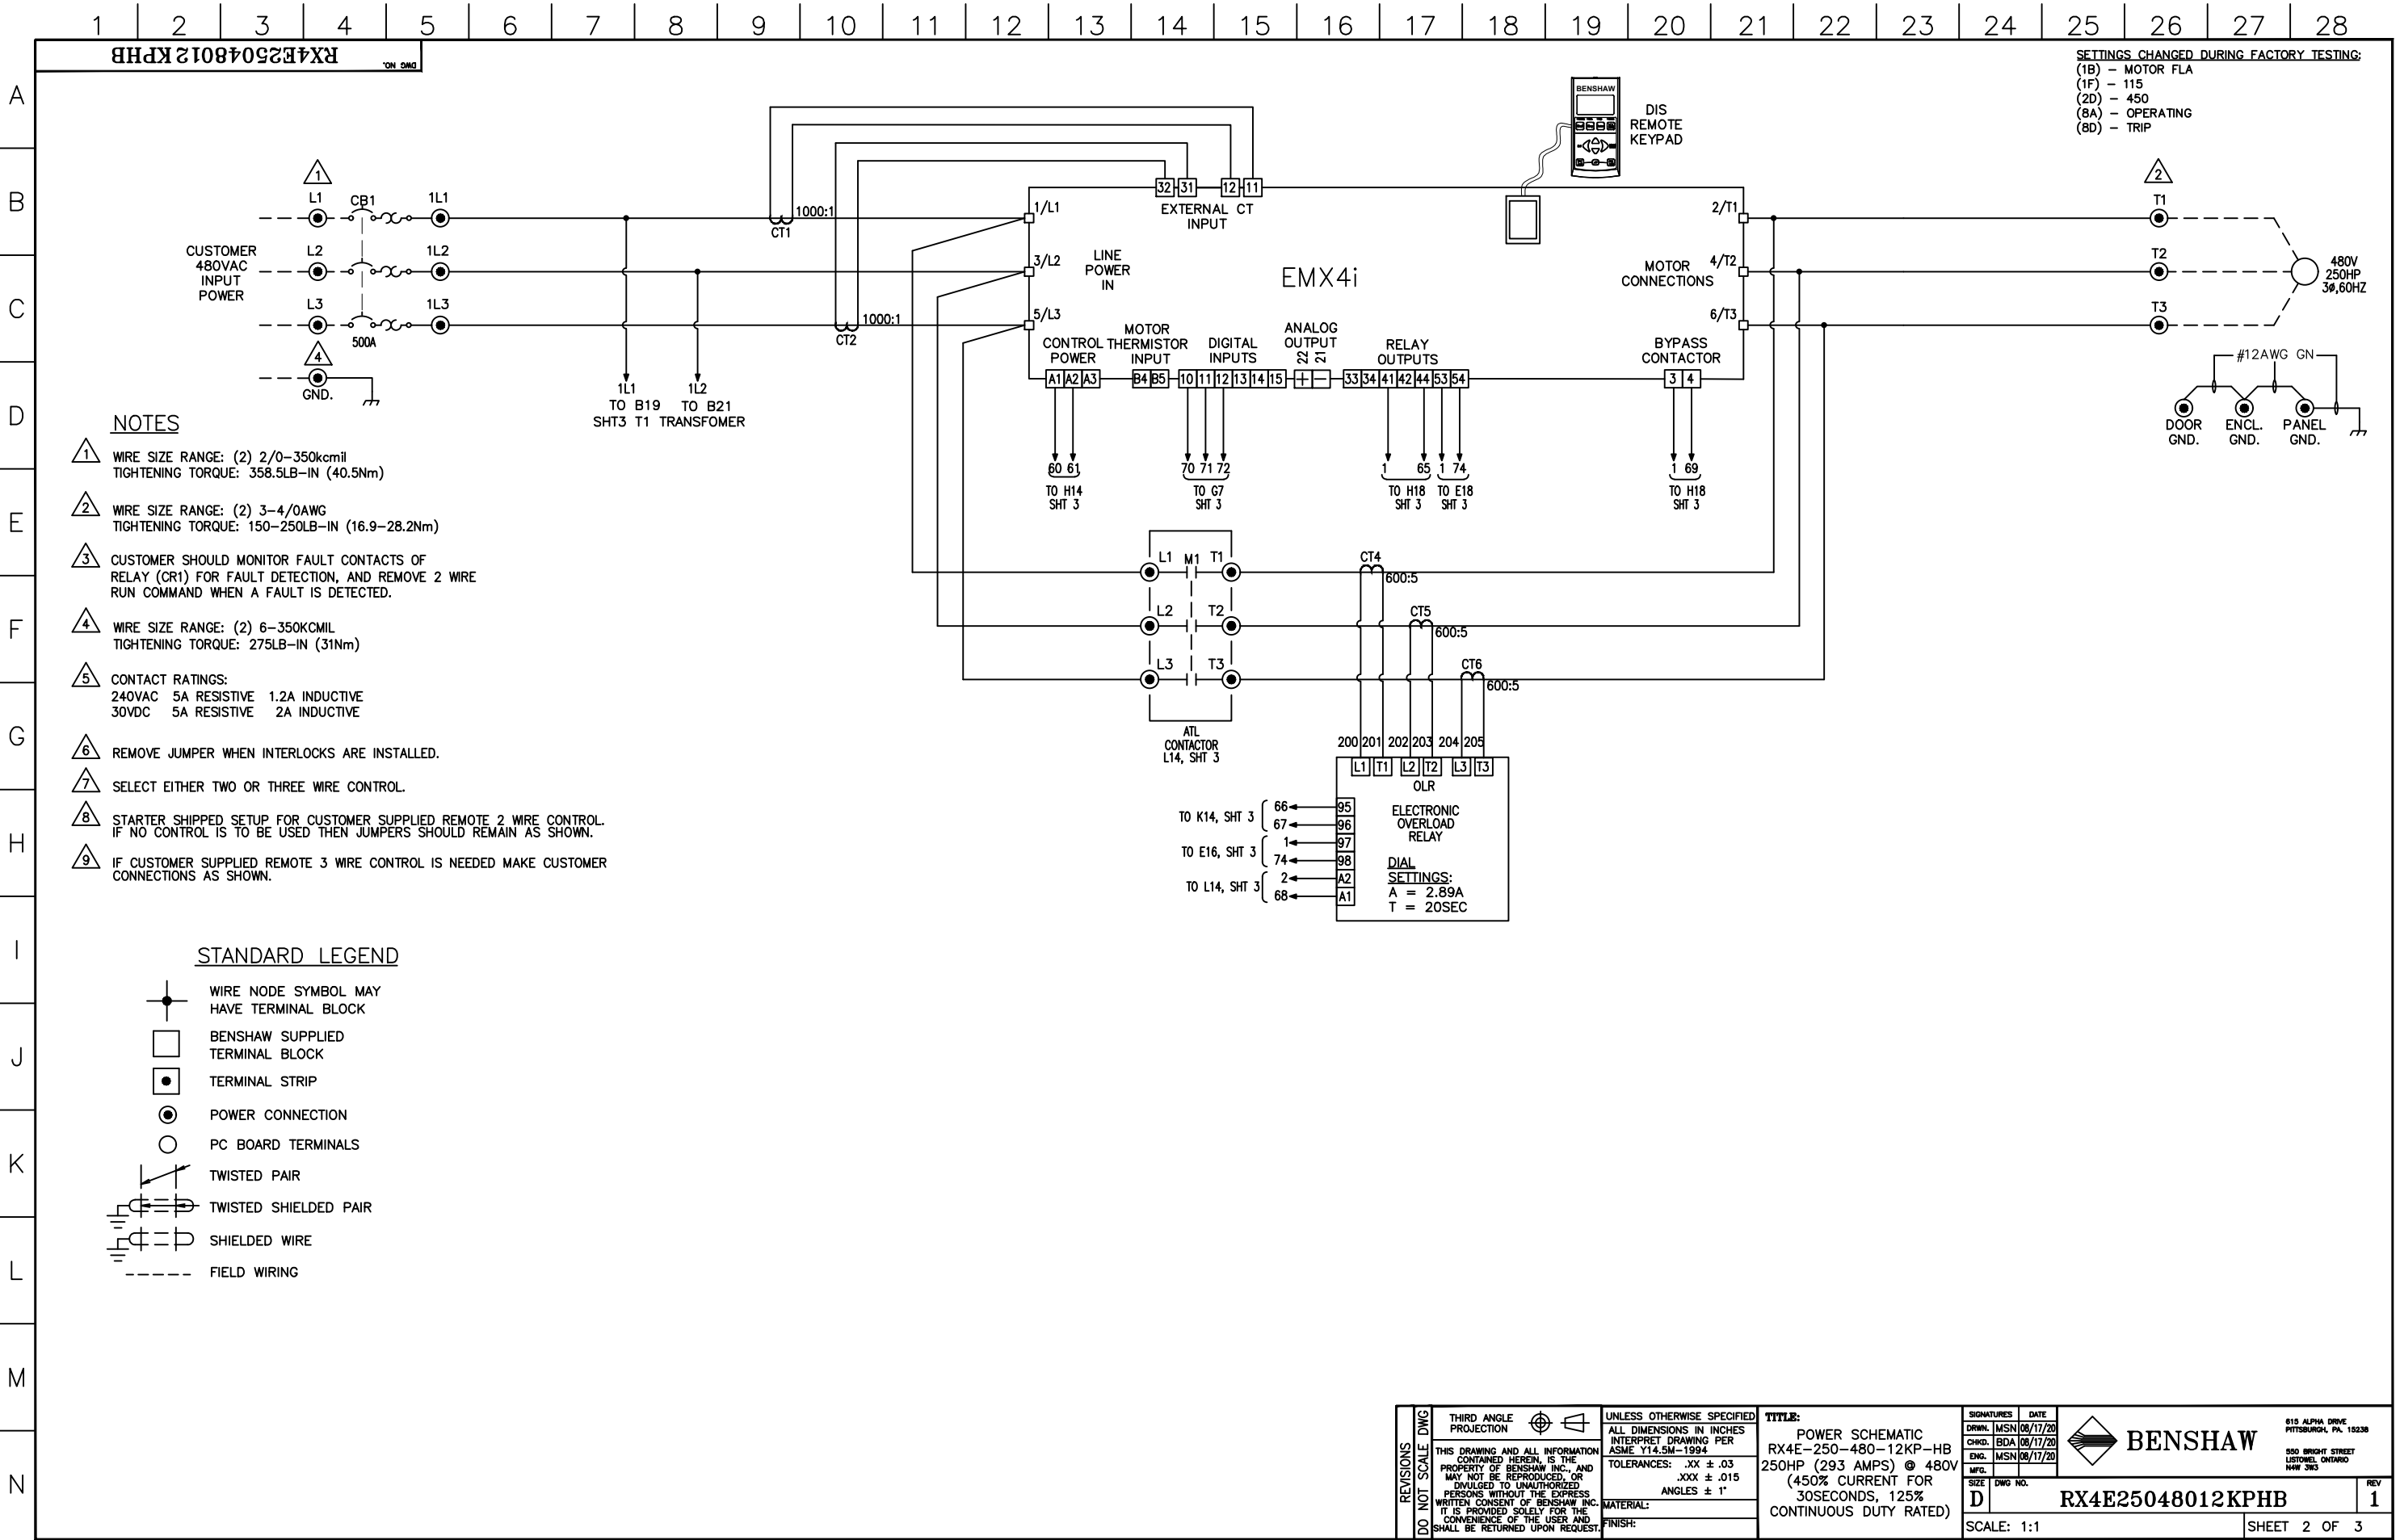

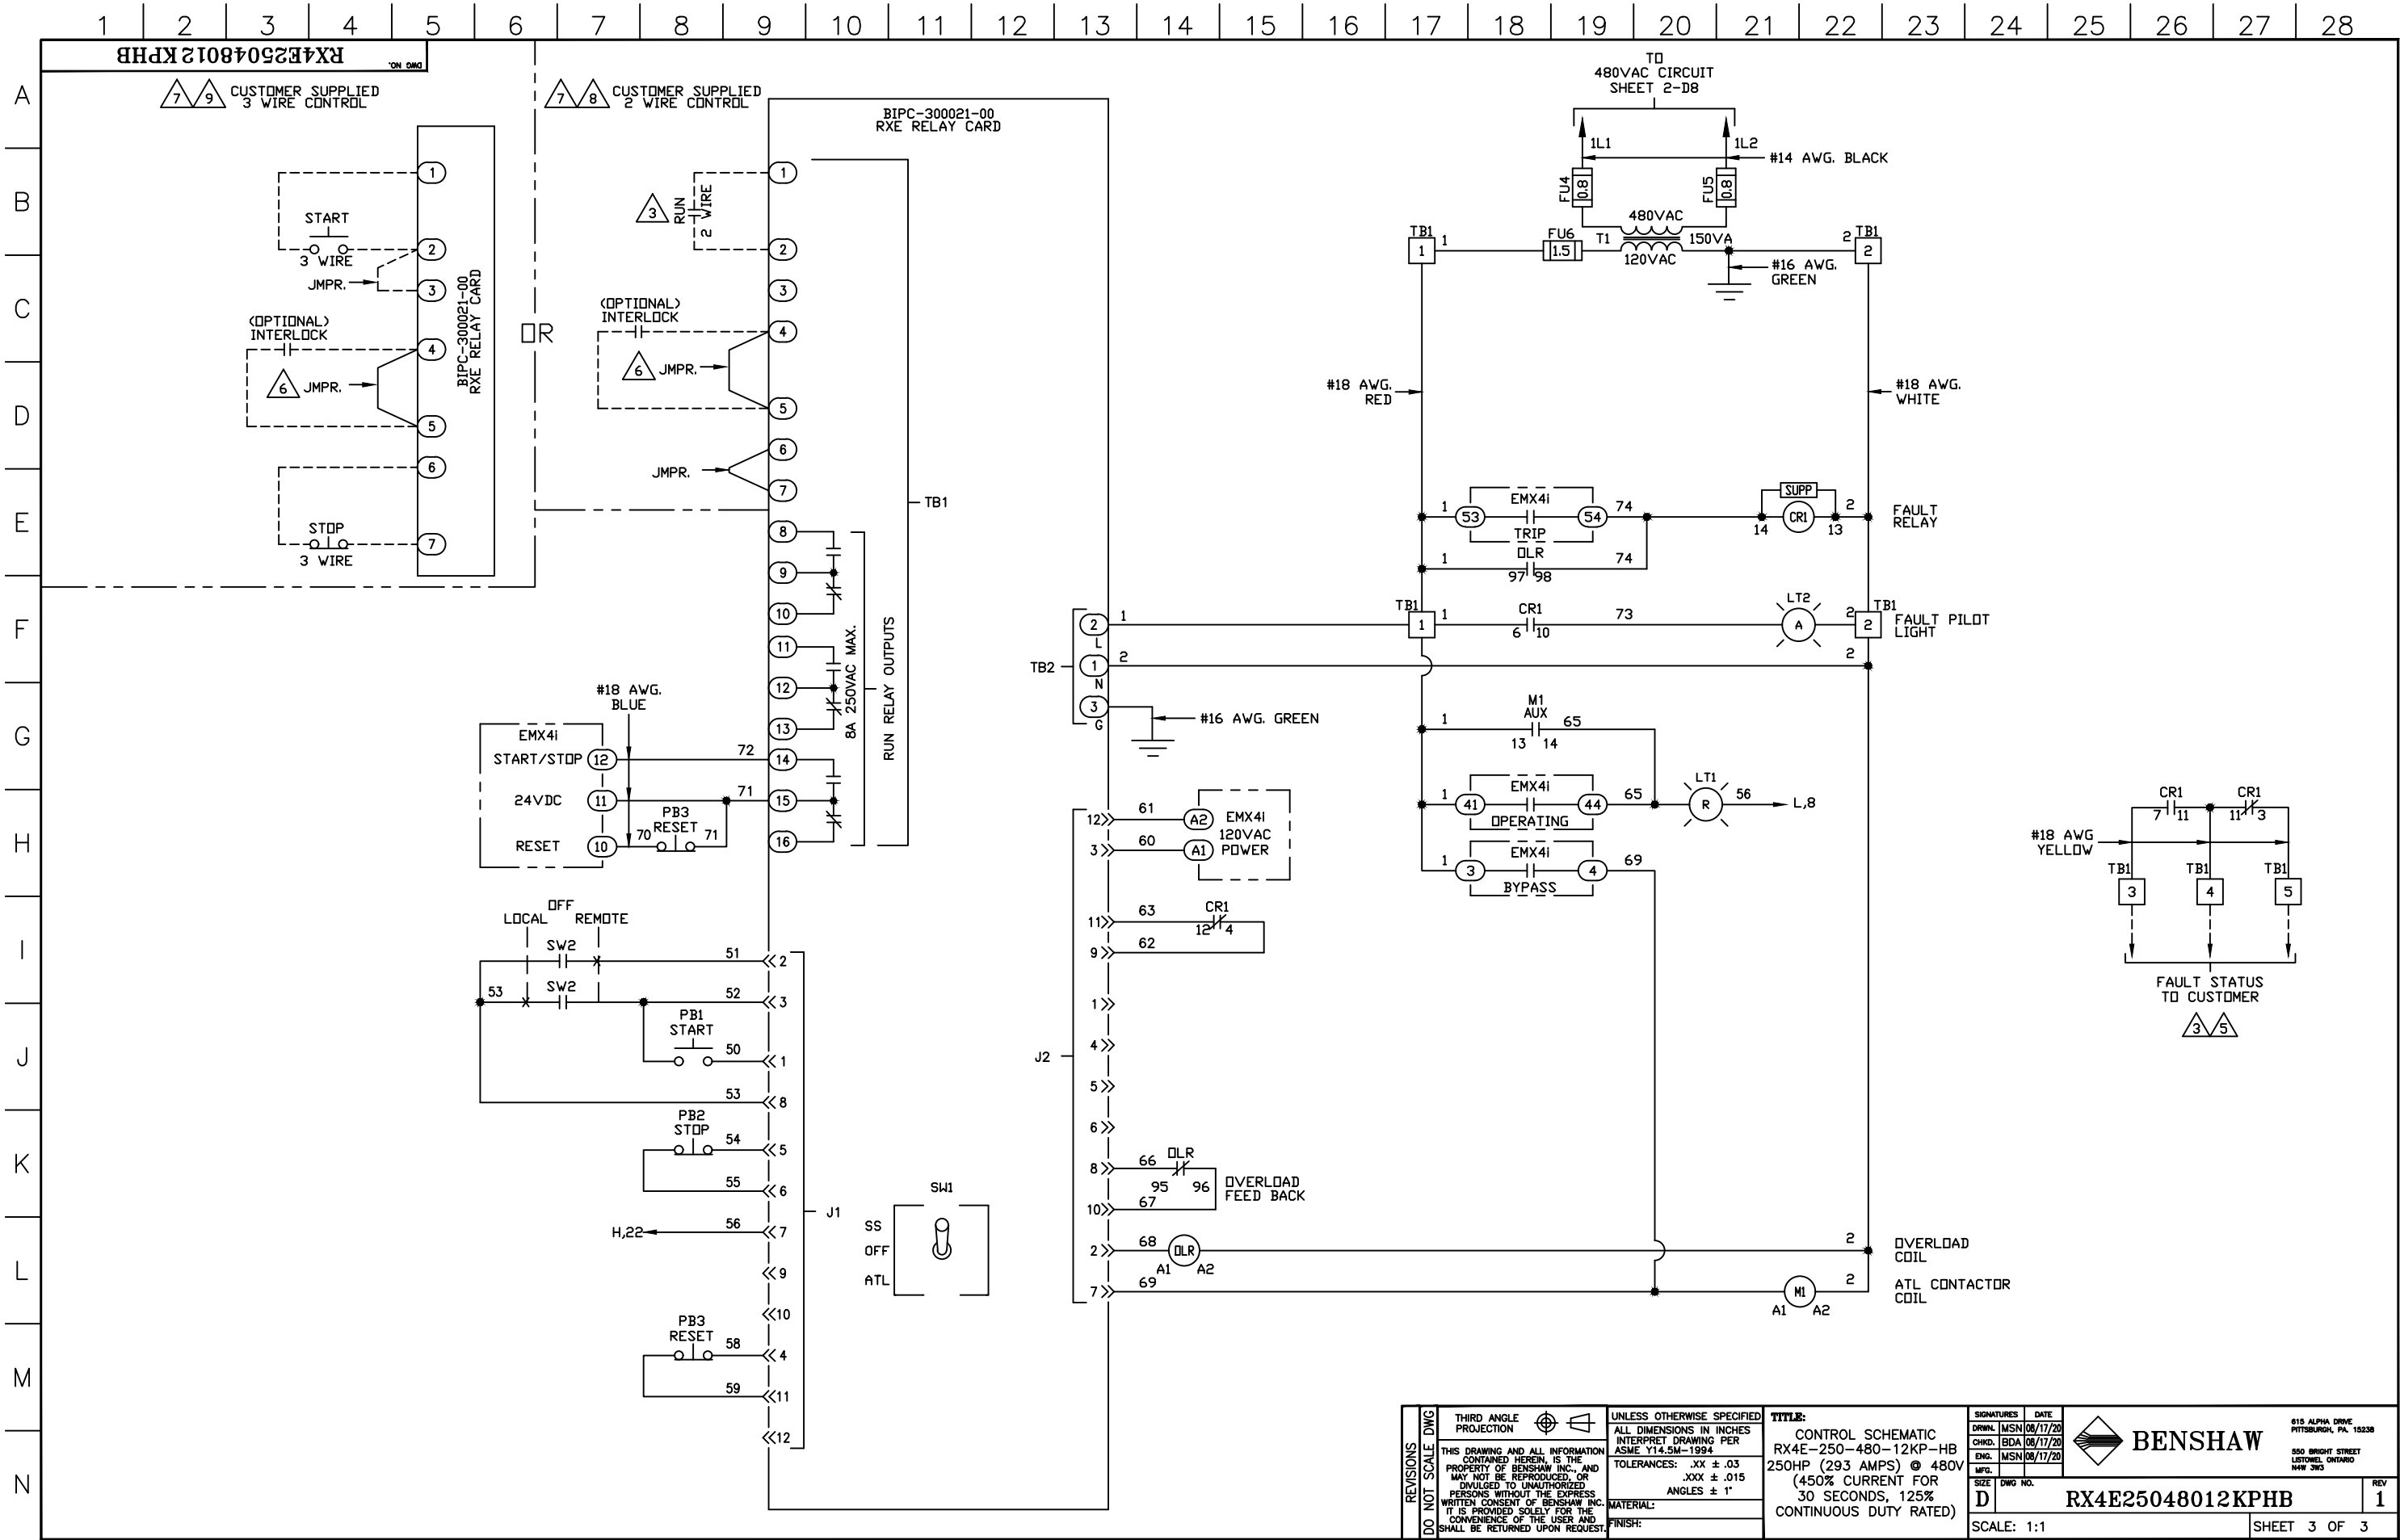

REVISIONS DO NOT SCALE DWG	THIRD ANGLE PROJECTION	UNLESS OTHERWISE SPECIFIED ALL DIMENSIONS IN INCHES INTERPRET DRAWING PER ASME Y14.5M-1994 TOLERANCES: .XX ± .03 .XXX ± .015 ANGLES ± 1° MATERIAL: FINISH:	TITLE: CONTROL SCHEMATIC RX4E-250-480-12KP-HB 250HP (293 AMPS) @ 480V (450% CURRENT FOR 30 SECONDS, 125% CONTINUOUS DUTY RATED)	SIGNATURES DRWN: MSN 08/17/20 CHKD: BDA 08/17/20 ENG: MSN 08/17/20 MFG: SIZE: D DWG NO.: SCALE: 1:1	DATE 08/17/20 08/17/20 08/17/20 REV 1
	THIS DRAWING AND ALL INFORMATION CONTAINED HEREIN, IS THE PROPERTY OF BENSCHAW INC., AND MAY NOT BE REPRODUCED, OR DIVULGED TO UNAUTHORIZED PERSONS WITHOUT THE EXPRESS WRITTEN CONSENT OF BENSCHAW INC. IT IS PROVIDED SOLELY FOR THE CONVENIENCE OF THE USER AND SHALL BE RETURNED UPON REQUEST.				

**BENSCHAW**

615 ALPHA DRIVE
PITTSBURGH, PA. 15238
550 BRIGHT STREET
LITTONEL, ONTARIO
M4W 3W5